




LOWER BASEMENT PLAN

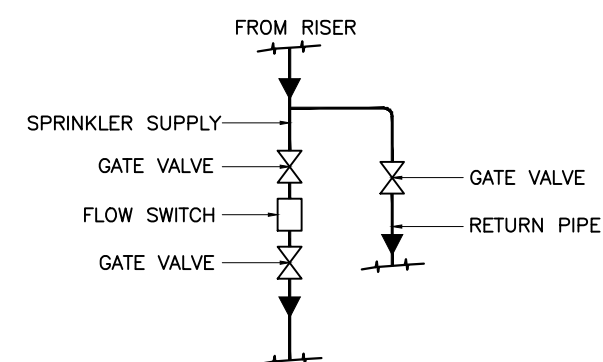

TYPICAL FLOW SWITCH ASSEMBLY DETAIL

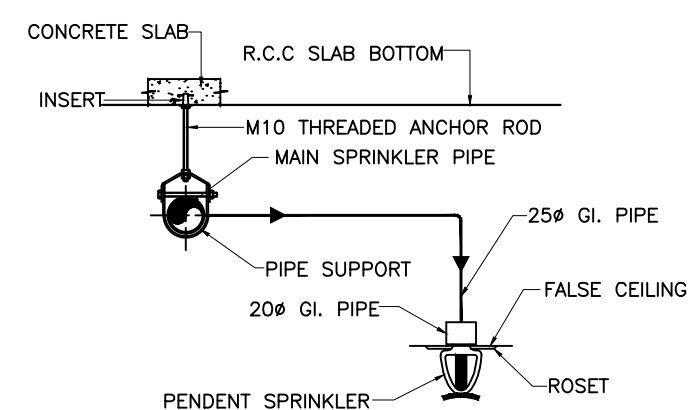

TYPICAL SPRINKLER INSTALLATION DETAIL

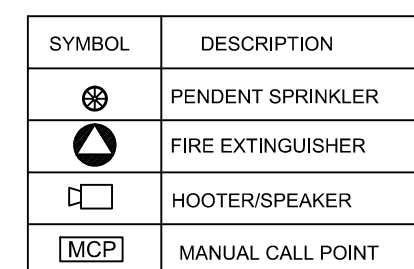

D3

HOSEREEL WITH DRUM

HYDRANT VALVE


150Ø FIRE RISER

150Ø SPRINKLER RISER

80Ø DRAIN PIPE

C32

DETAIL 'A' - FIRE DUCT DETAIL

STAMP OF DATE OF RECEIPT OF PLANS:-		<div>DESIGN IDEAS</div> <p> PLOT NO-1 63E, 1 02,VASANT KUNJ, Dr-AMBEDKAR ROAD,OPP.PARSI GYMKHANA, DADAR (EAST), MUMBAI-14 TELEFAX : 022-24121713 </p>	
STAMP OF APPROVAL OF PLANS:-			
CONTENTS OF THE SHEET:- FLOOR PLAN		DRAWING TITLE:- FIRE FIGHTING LAYOUT	
NAME OF THE OWNER:- HLL Lifecare Ltd. TRIVENDRUM.		JOB TITLE:- PROPOSED CANTEN CUILDING, At AKKULAM.	
NORTH:- 	REMARKS:-	JOB NO.:-	DRWG. NO.:- HLL/P 1 -APP/02 <div>REV. SUFFIX</div>
		SCALE 1:100	DATE 07.06.12 DRAWN PRIYANKA CHECKED EARTH