


BIOWASTE INACTIVATION SYSTEM

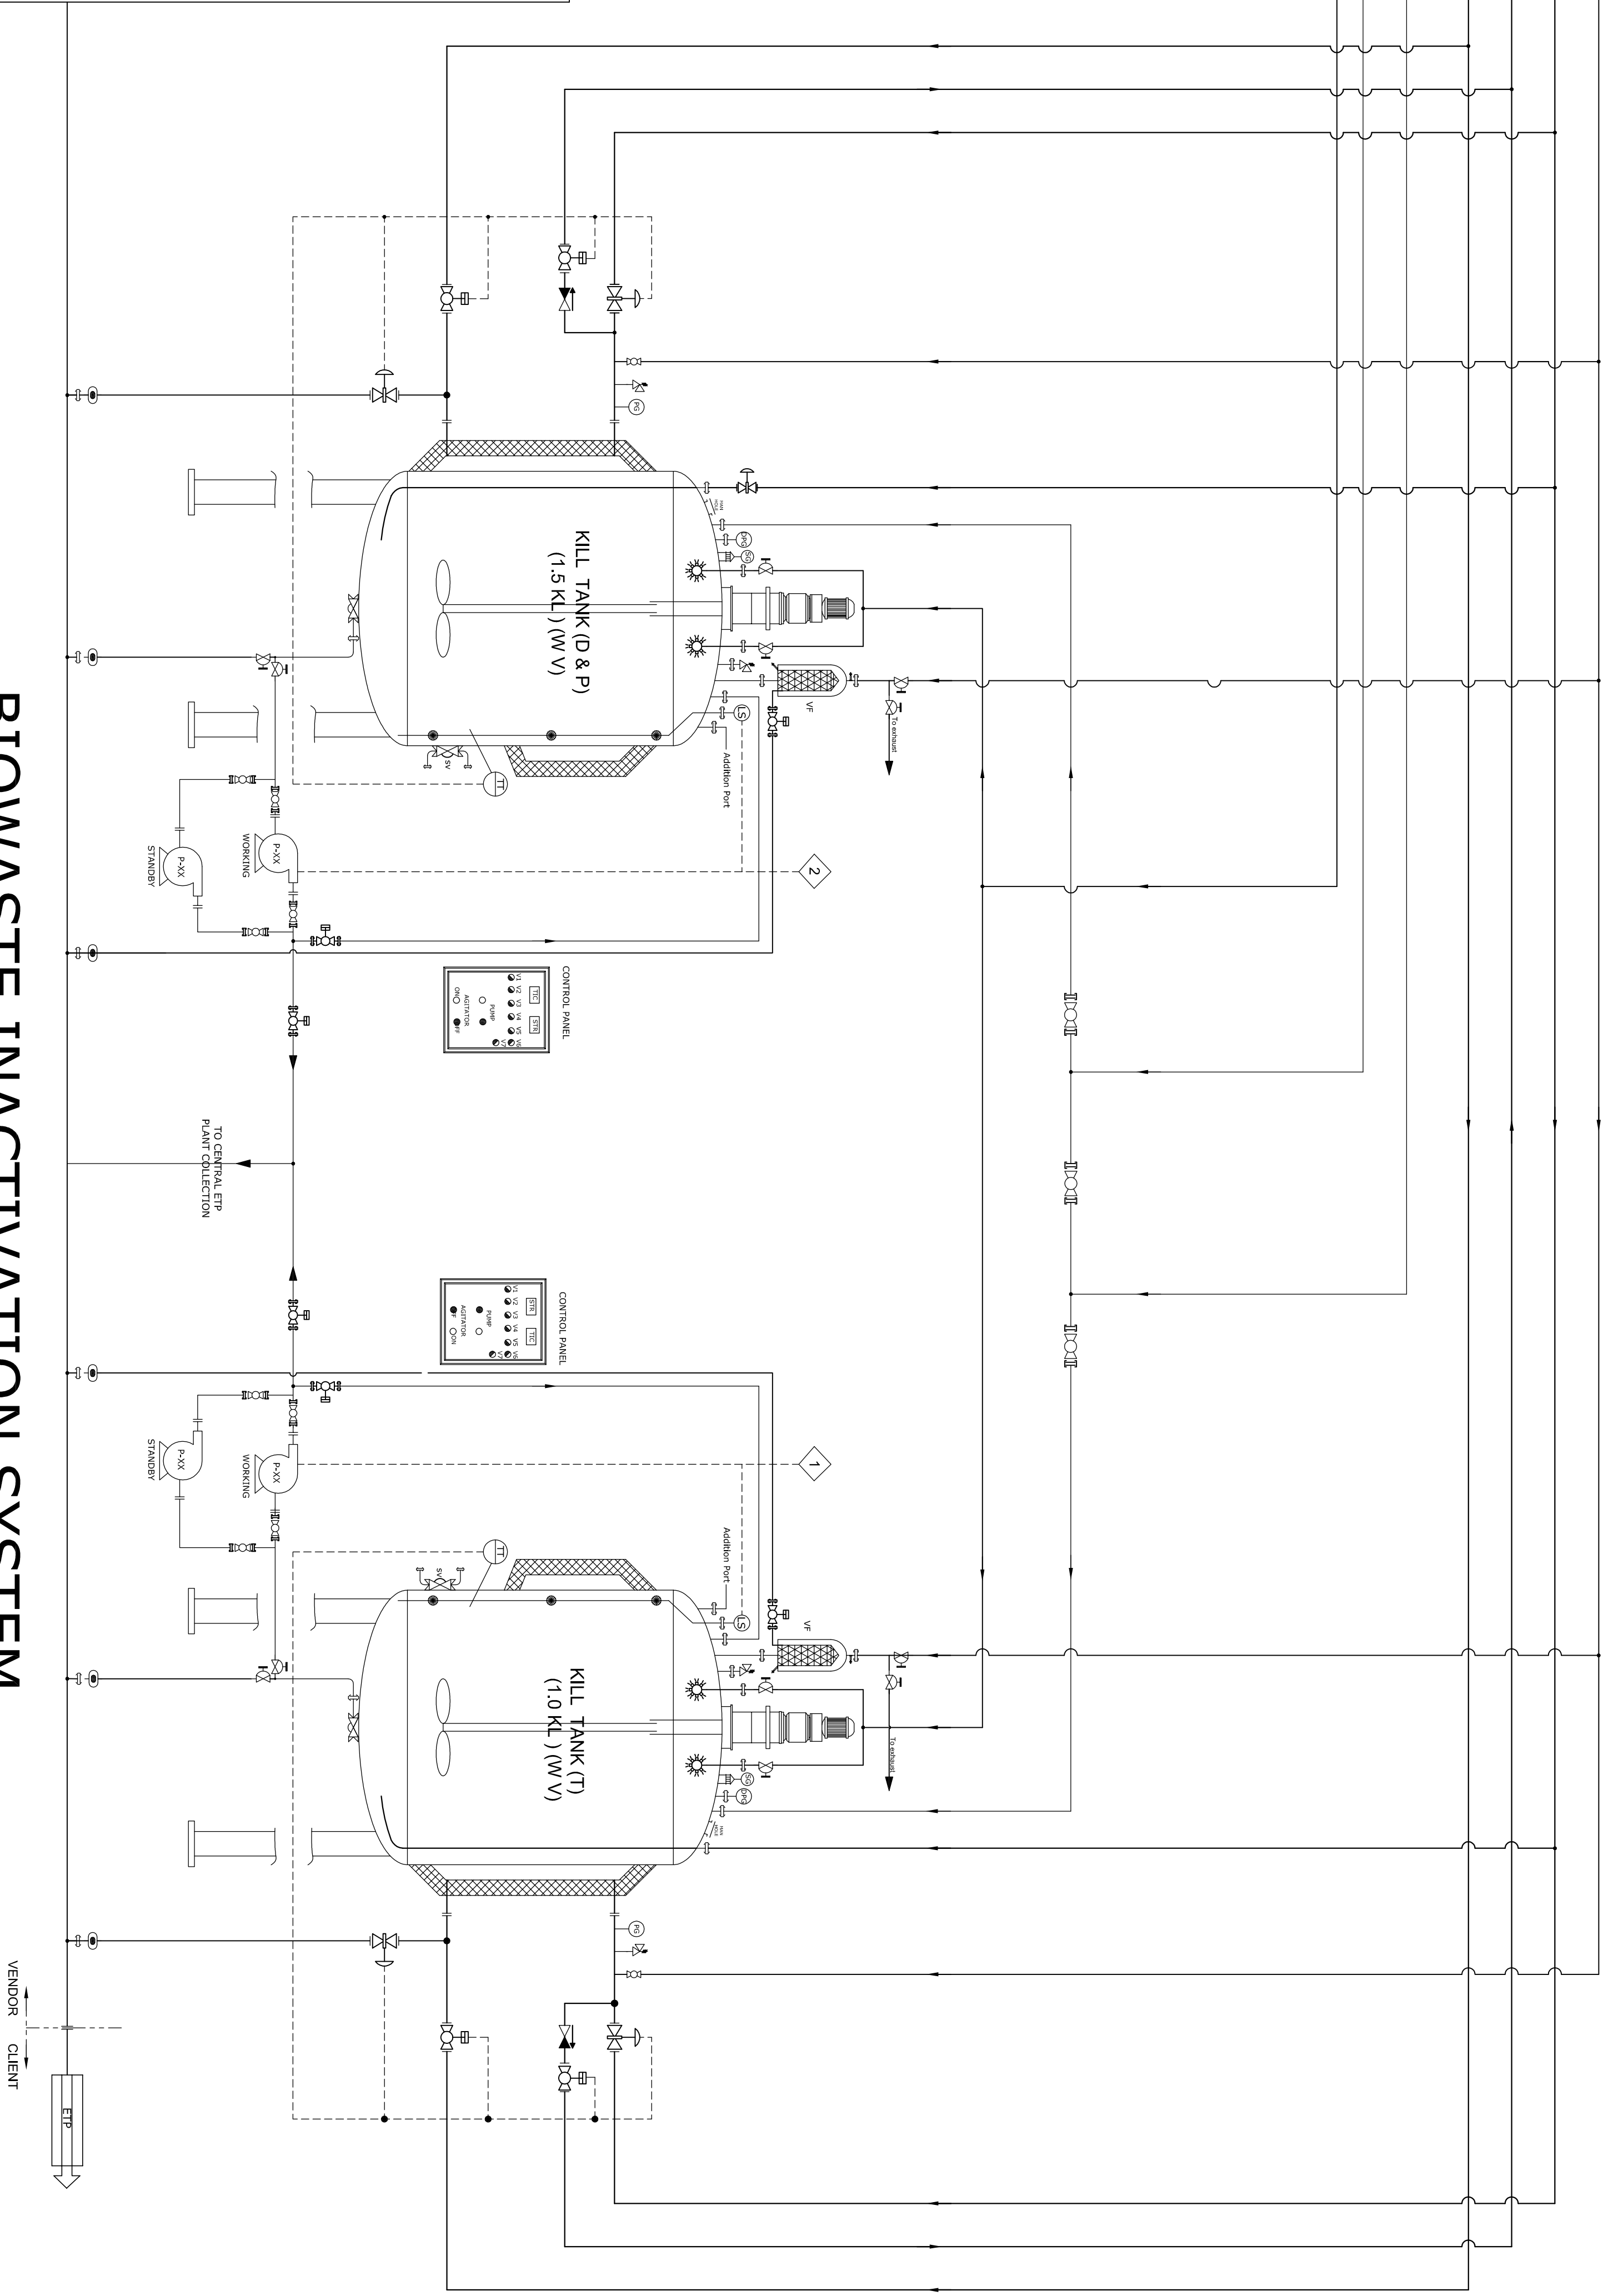

Note: This is an indicative drawing, actual P&ID shall be given by the vendor.

03	2015.03.09	SRTR	SRKV	Revised as per URS				
02	2014.12.01	SAPL	SRKV	Revised as per URS				
01	2014.10.28	SAPL	SRKV	Revised as per URS				
Rev.	Date	Changed	Checked	Kind of revision	No. Of Prints	Date	Issued To	Rev.

File name :

Originated From Dwg. No :

Project:  
HIL LIFE CARE LIMITED  
PASTEUR INSTITUTE OF INDIA, COONOOR

Project No.: 110831  
Location: COONOOR  
**nne pharmaplan®**  
NNE Pharmaplan India Limited  
# 12, Achian Shetty Layout,  
Bangalore - 560 080 , INDIA.

Description:  
**P&ID FOR BIOWASTE INACTIVATION SYSTEM**

Drawn	2014.10.28	SRTR	
Checked	2014.10.28	SRKV	
Approved	2014.10.29	VKKA	
Scale-NTS	Units : mm	Size : A3	
Drawing no:	NP/110831/EOP/P&ID/KI-KLT 01		
Rev.	03		

Symbol	Description	Symbol	Description	Symbol	Description
	Manual Ball Valve		Check Valve		Temp. Transmitter
	Actuated Ball Valve		Safety Relief Valve		Temp. Transmitter
	Manual Diaphragm Valve		Tidcover Connector		
	Actuated Diaphragm valve		Level Sensor		
	Sampling Valve		Diaphragm Pressure Gauge		
	Flush Bottom Valve		Sight Glass		
	Float Trap		Spray Ball		
	Actuated Piston Valve		Pressure Regulating Valve		

COLOR CODE	
STEAM	
CONDENSATE	
COOLING WATER SUPPLY	
COOLING WATER RETURN	
COMPRESSED AIR	
BIOWASTE	
SOFT WATER	
FTP DRAIN	
SIGNALS	