

LEGEND

- DW

DOMESTIC WATER LINE
- HF

HEALTH FAUSET
- WB

WASH BASIN
- EW

EUROPEAN WATER CLOSET
- BV

BALL VALVE
- SV

SHUT OFF VALVE
- SP

SOIL PIPE
- WP

WASTE PIPE


52.28M- SITE

22.98M- SITE

54.29M- SITE

22.85M- SITE

18 M ROAD

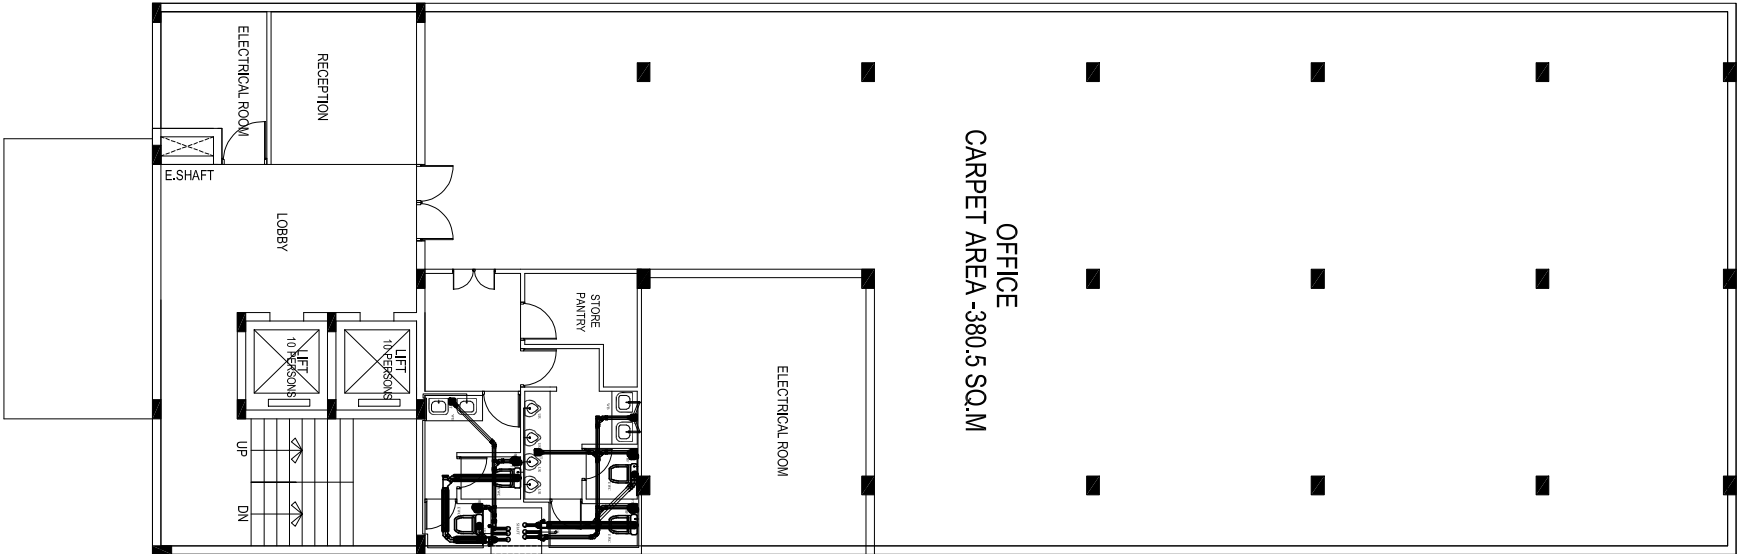

CLIENT:

H L L LIFE CARE LTD.
(A GOVERNMENT OF INDIA ENTERPRISE)
HITES
(HLL INFRA TECH SERVICES LTD)
VELACHERY,CHENNAI
web : www.lifecarehl.com

PROJECT:

PROPOSED OFFICE BUILDING
AT PALLIKARANAI
CHENNAI

PROJECT CONSULTANT:

CARE CONSULTANTS AND CONTRACTORS
CHINMAYA NAGAR STAGE - II,
25/C, AANI STREET,
VIRUGAMBAKKAM,
CHENNAI - 600 092.
E-MAIL: caretech1995@gmail.com

ARCHITECTS:

AKSHARA ASSOCIATES
ARCHITECTS & ENGINEERS
Plot No.82, 1st Floor, Gopalan Street,
Vasudevan Nagar, Chennai 600 083
Tel / Fax : 044 2471 7557
Mobile : 94440 02589
Email I.D : aksharassociates@yahoo.in
shivabalu2005@yahoo.co.in

MEP CONSULTANTS:

CARE CONSULTANTS AND CONTRACTORS

STRUCTURAL CONSULTANTS:

C.KANNAN B.E., (MEISTRUCTURE)
L1932,SSKILLAM,
THIRUVALUVAR NAGAR, THIRUVANMIVUR,
CHENNAI-41,
MOBILE NO:-098412.49815,
E-MAIL:kannancks2007@rediffmail.com

DRAWING TITLE

FIRST FLOOR PLAN
PLUMBING LAYOUT

Drawn: V.S	Checked: V.S
Approved: KRISHNAN	Scale: 1:100
Date: 16.07.15	Sheet: A2
Drq No: CC\PLU\PJ20\PL-03	Rev:R0
File Path: C:\sheet\16.07.15\drq\plumbing\drainage and soil\1st floor\plumbing\first floor.dwg	