












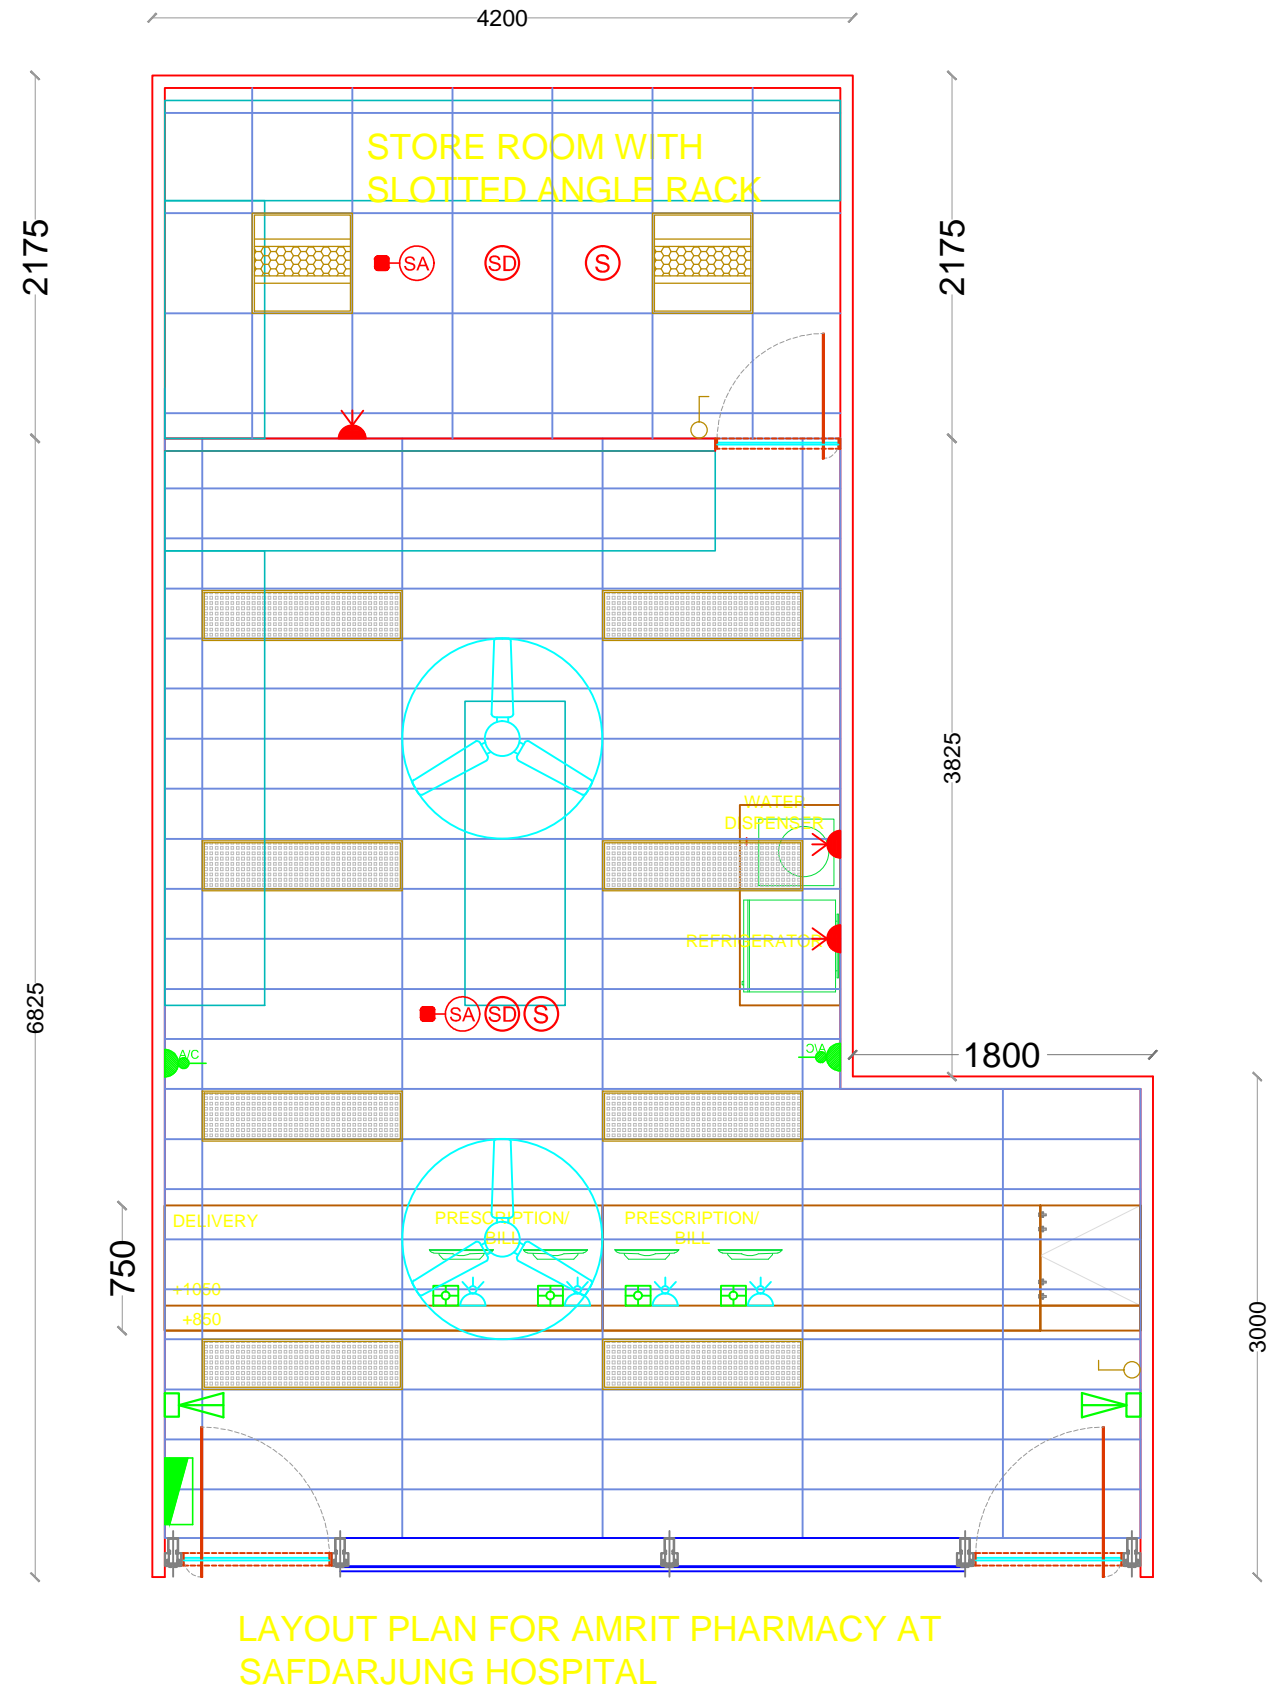



ELECTRICAL LEGEND		
Symbol	Description	HEIGHT OF FFL.
	2X28W T-5 LIGHT FIXTURE	CEILING
	3X14W T-5 LIGHT FIXTURE	CEILING
	2NOS. DATA AND 1NO. VOICE OUTLET	230
	4NOS. 13AMP UNIVERSAL SOCKET (UPS) WITH 1NO. 16AMP SWITCH	230
	1NO. 16AMP UNIVERSAL SOCKET (RAW) WITH 1NO. 16AMP SWITCH	230
	DISTRIBUTION BOARD (LIGHT, POWER & UPS)	1500
	SWITCH BOARD	1050
	CCTV CAMERA	CEILING
	SMOKE DETECTOR BELOW FALSE CEILING	CEILING
	2WATT SPEAKER FOR PA SYSTEM	CEILING
	SMOKE DETECTOR ABOVE FALSE CEILING WITH RI	CEILING
	20A SWITCH SOCKET FOR AC	AS PER SITE
	CEILING FAN	CEILING



DWG. NO : <b>P(60) T001</b>		REV NO : <b>01</b>	DMS DESIGNS C1-2777, Sushant lok –I, Gurgaon – 122009 Tel: +91-124-4227638 Email: info@dmsdesigns.co.in Web: www.dmsdesigns.co.in	
DWG. TITLE : <b>ELECTRICAL LAYOUT</b>				
Scale : <b>1:50</b>	<b>PROJECT : PROPOSED LAYOUT OUT FOR AMRIT PHARMACY SAFDARJUNG HOSPITAL</b>			
Checked By : <b>Jc</b>				
Dealt By : <b>JS</b>				
Date : <b>02.02.16</b>	STAGE : <b>TENDER</b>		REGISTERED : THIS DRAWING IS AN OFFICIAL PROPERTY OF DMS DESIGNS & CONSULTANTS-NEW DELHI	