





 


 



LEGENDS	
	SUPPLY AIR DIFFUSER
	RETURN AIR DIFFUSER
	SPLIT AC OUTDOOR UNIT
	SPLIT AC INDOOR UNIT
	CASSETTE AC
	DUCTABLE SPLIT UNIT
	SUPPLY AIR DUCT
	REFRIGERANT PIPE
	PVC DRAIN PIPE
	VOLUME CONTROL DAMPER

Sill Height : 75 cm

SCHEDULE OF OPENINGS - FIRST FLOOR			
MARK	SIZE	TYPE	No.
DOORS			
SD	200 x 240	FRAMELESS TOUGHENED GLASS DOOR	1
D	180 x 225	GLAZED ALUMINIUM DOUBLE DOOR	3
D'	180 x 225	FRAMELESS TOUGHENED GLASS DOUBLE DOOR	
D''	150 x 225	GLAZED ALUMINIUM DOUBLE DOOR	
D0	120 x 225	GLAZED ALUMINIUM DOOR	
D1	100 x 225	FRAMELESS TOUGHENED GLASS DOOR	
D2	100 x 225	TEAK WOOD DOOR	
D3	100 x 225	HALF GLAZED ALUMINIUM DOOR	
D4	90 x 225	ALUMINIUM DOOR WITH PARTICLE BOARD	1
D5	80 x 210	PVC DOOR	
FD	90 x 150	PVC DOOR	1
DD	60 x 150	PVC DOOR	
RS	AS PER DESIGN	ROLLING SHUTTER	
WINDOWS			
W	180 x 150	GLAZED ALUMINIUM WINDOW	
W1	300 x 210	GLAZED ALUMINIUM WINDOW	1
W2	400 x 120	GLAZED ALUMINIUM LOUVERED WINDOW	
W3	120 x 150	GLAZED ALUMINIUM WINDOW	
W4	120 x 135	GLAZED ALUMINIUM WINDOW	
V	90 x 60	GLAZED ALUMINIUM VENTILATOR	
V1	60 x 60	GLAZED ALUMINIUM VENTILATOR	1

AREA	
GF	477 SQ.M
1ST FL	464 SQ.M
2ND FL	464 SQ.M
3RD FL	464 SQ.M
4TH FL	464 SQ.M
5TH FL	464 SQ.M
6TH FL	464 SQ.M
STR RM	209 SQ.M
TOTAL	3470 SQ.M

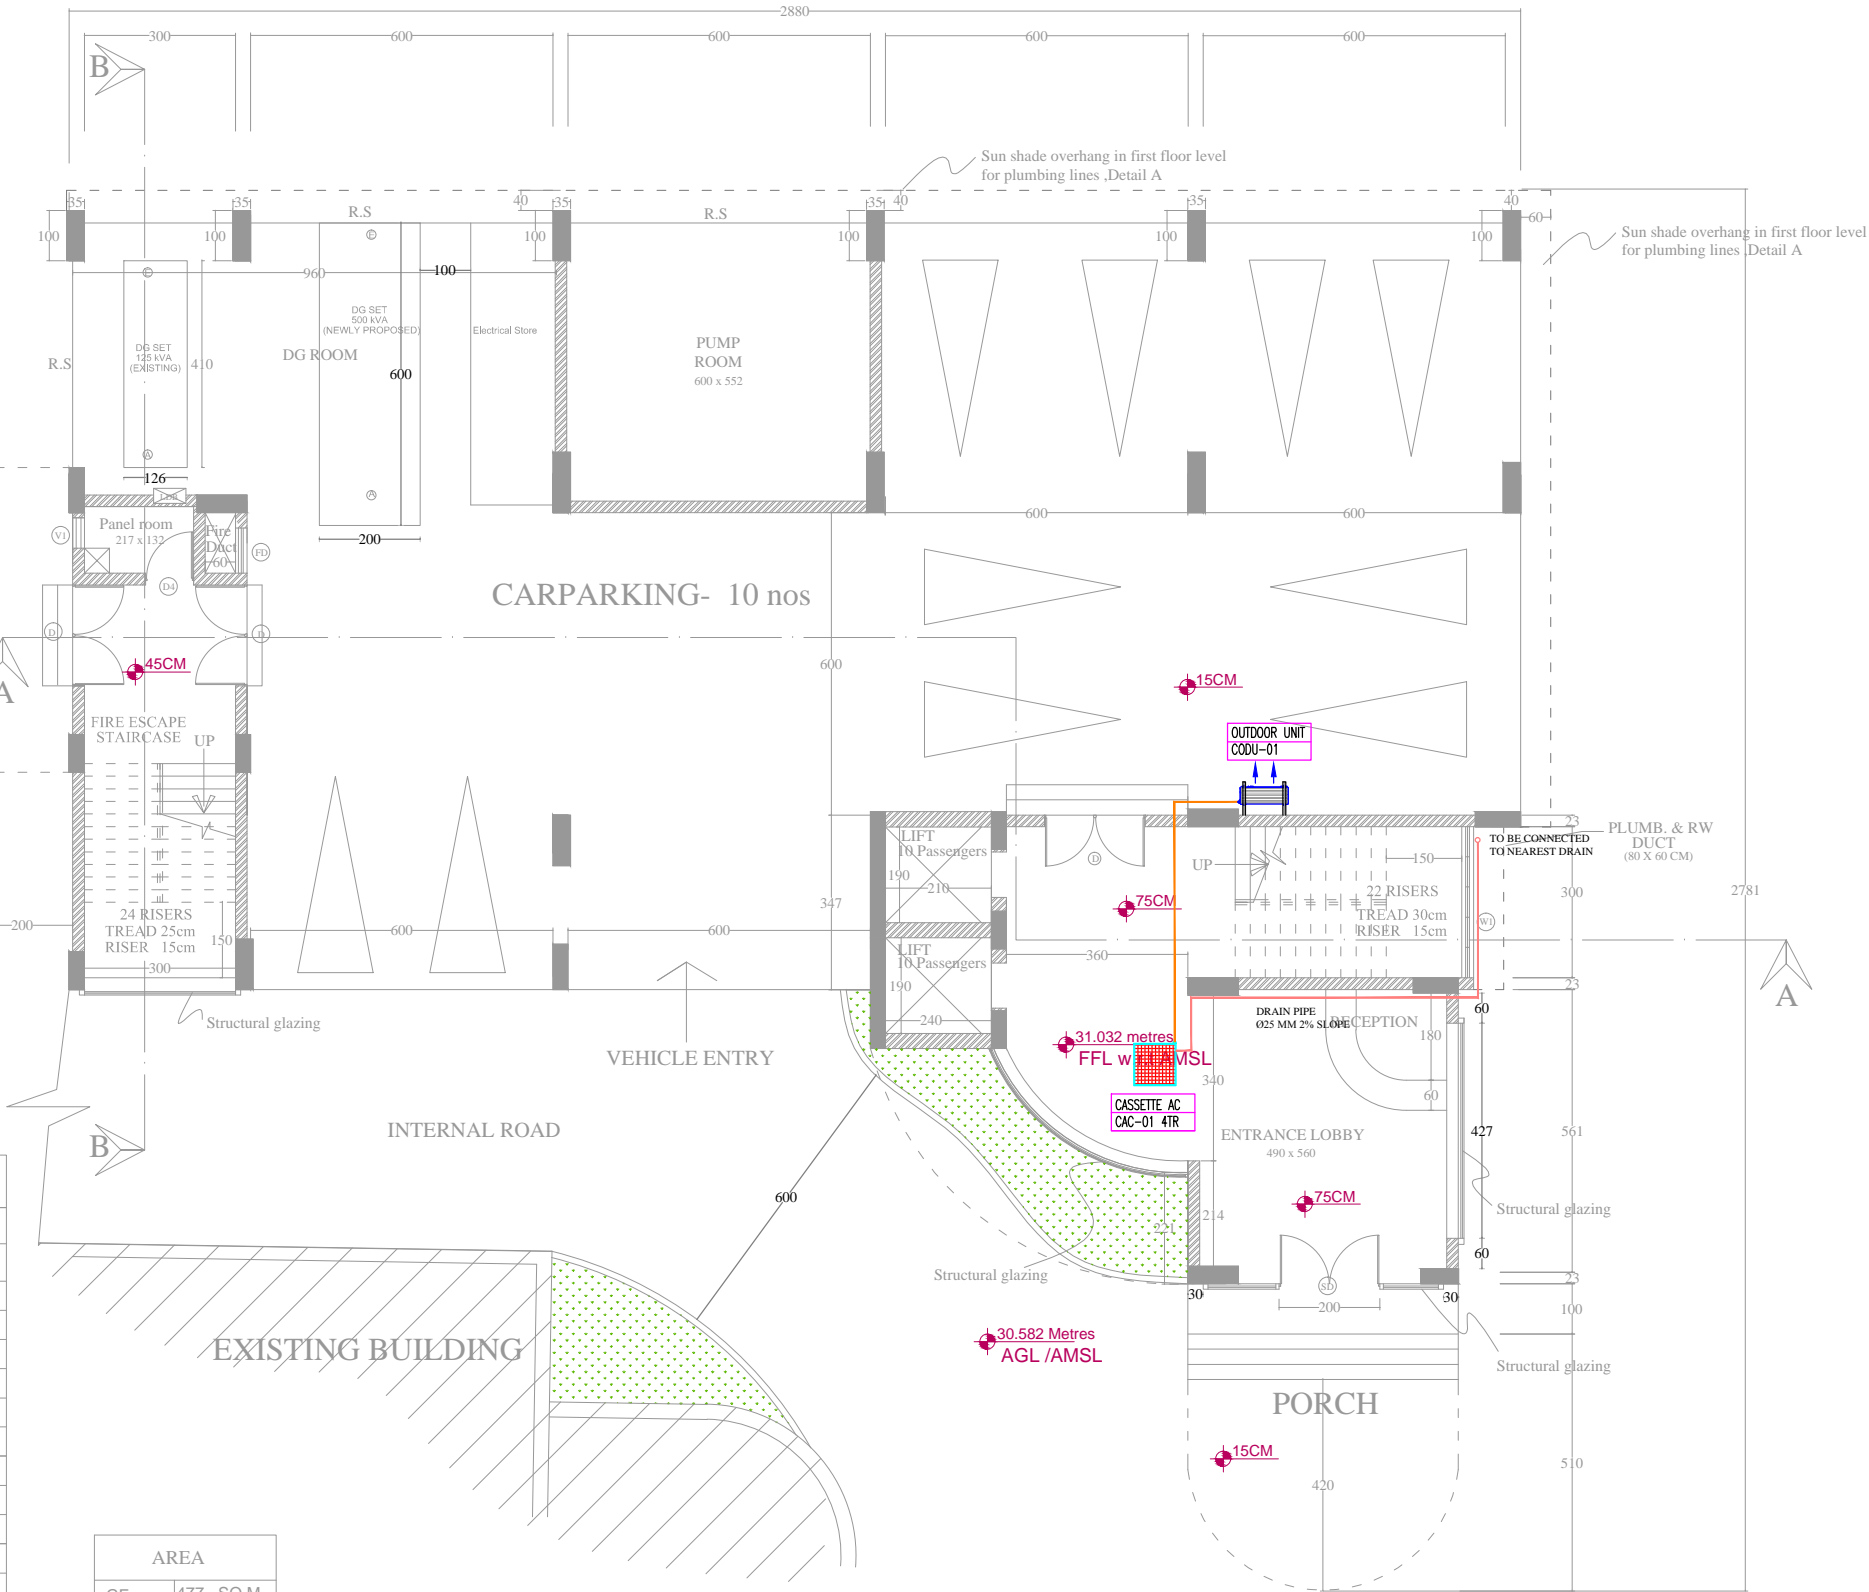

NOTE
REFER STRUCTURAL DRAWINGS FOR ACCURATE
DIMENSIONS OF STRUCTURAL MEMBERS LIKE
COLUMNS,BEAMS, LINTELS ETC.

REVISIONS				
NOS.	DATE	DESCRIPTION	DWN	CKD.
01	21-07-2015	FOR REFERENCE ONLY	JCT	PM



H LL LIFECARE LTD.
(A Government of India Enterprise)
INFRASTRUCTURE DEVELOPMENT
DIVISION
THIRUVANANTHAPURAM-6
TEL: 0471-2365872, 2365873
FAX: 0471- 2368144
web www.lifecarehll.com

PROJECT TITLE
**PROPOSED IDD OFFICE,
CHO PREMISES,
THIRUVANANTHAPURAM**

DRAWING TITLE
GROUND FLOOR HVAC PLAN

FOR REFERENCE ONLY

DATE: 21-07-2015
SCALE : 1:150
PAPER SIZE : A3

DRG. NO.
HLL/IDD/IP/IDS/CHO/2014-15/HVAC 01

ARCHITECT

- NOTE
- ALL DIMENSIONS ARE IN CENTIMETRES
 - DO NOT SCALE THE DRAWING
 - DISCLAIMER :THESE DRAWINGS ARE THE SOLE PROPERTY OF HLL LIFECARE LTD. NO CHANGES OR COPIES CAN BE MADE WITHOUT CONSENT
 - ANY DISCREPANCY SHALL BE IMMEDIATELY REFERED TO THE ARCHITECT FOR CLARIFICATION