





Your complimentary
use period has ended.
Thank you for using
PDF Complete.

Click Here to upgrade to
Unlimited Pages and Expanded Features

PRODUCED BY AN AUTODESK EDUCATIONAL PRODUCT

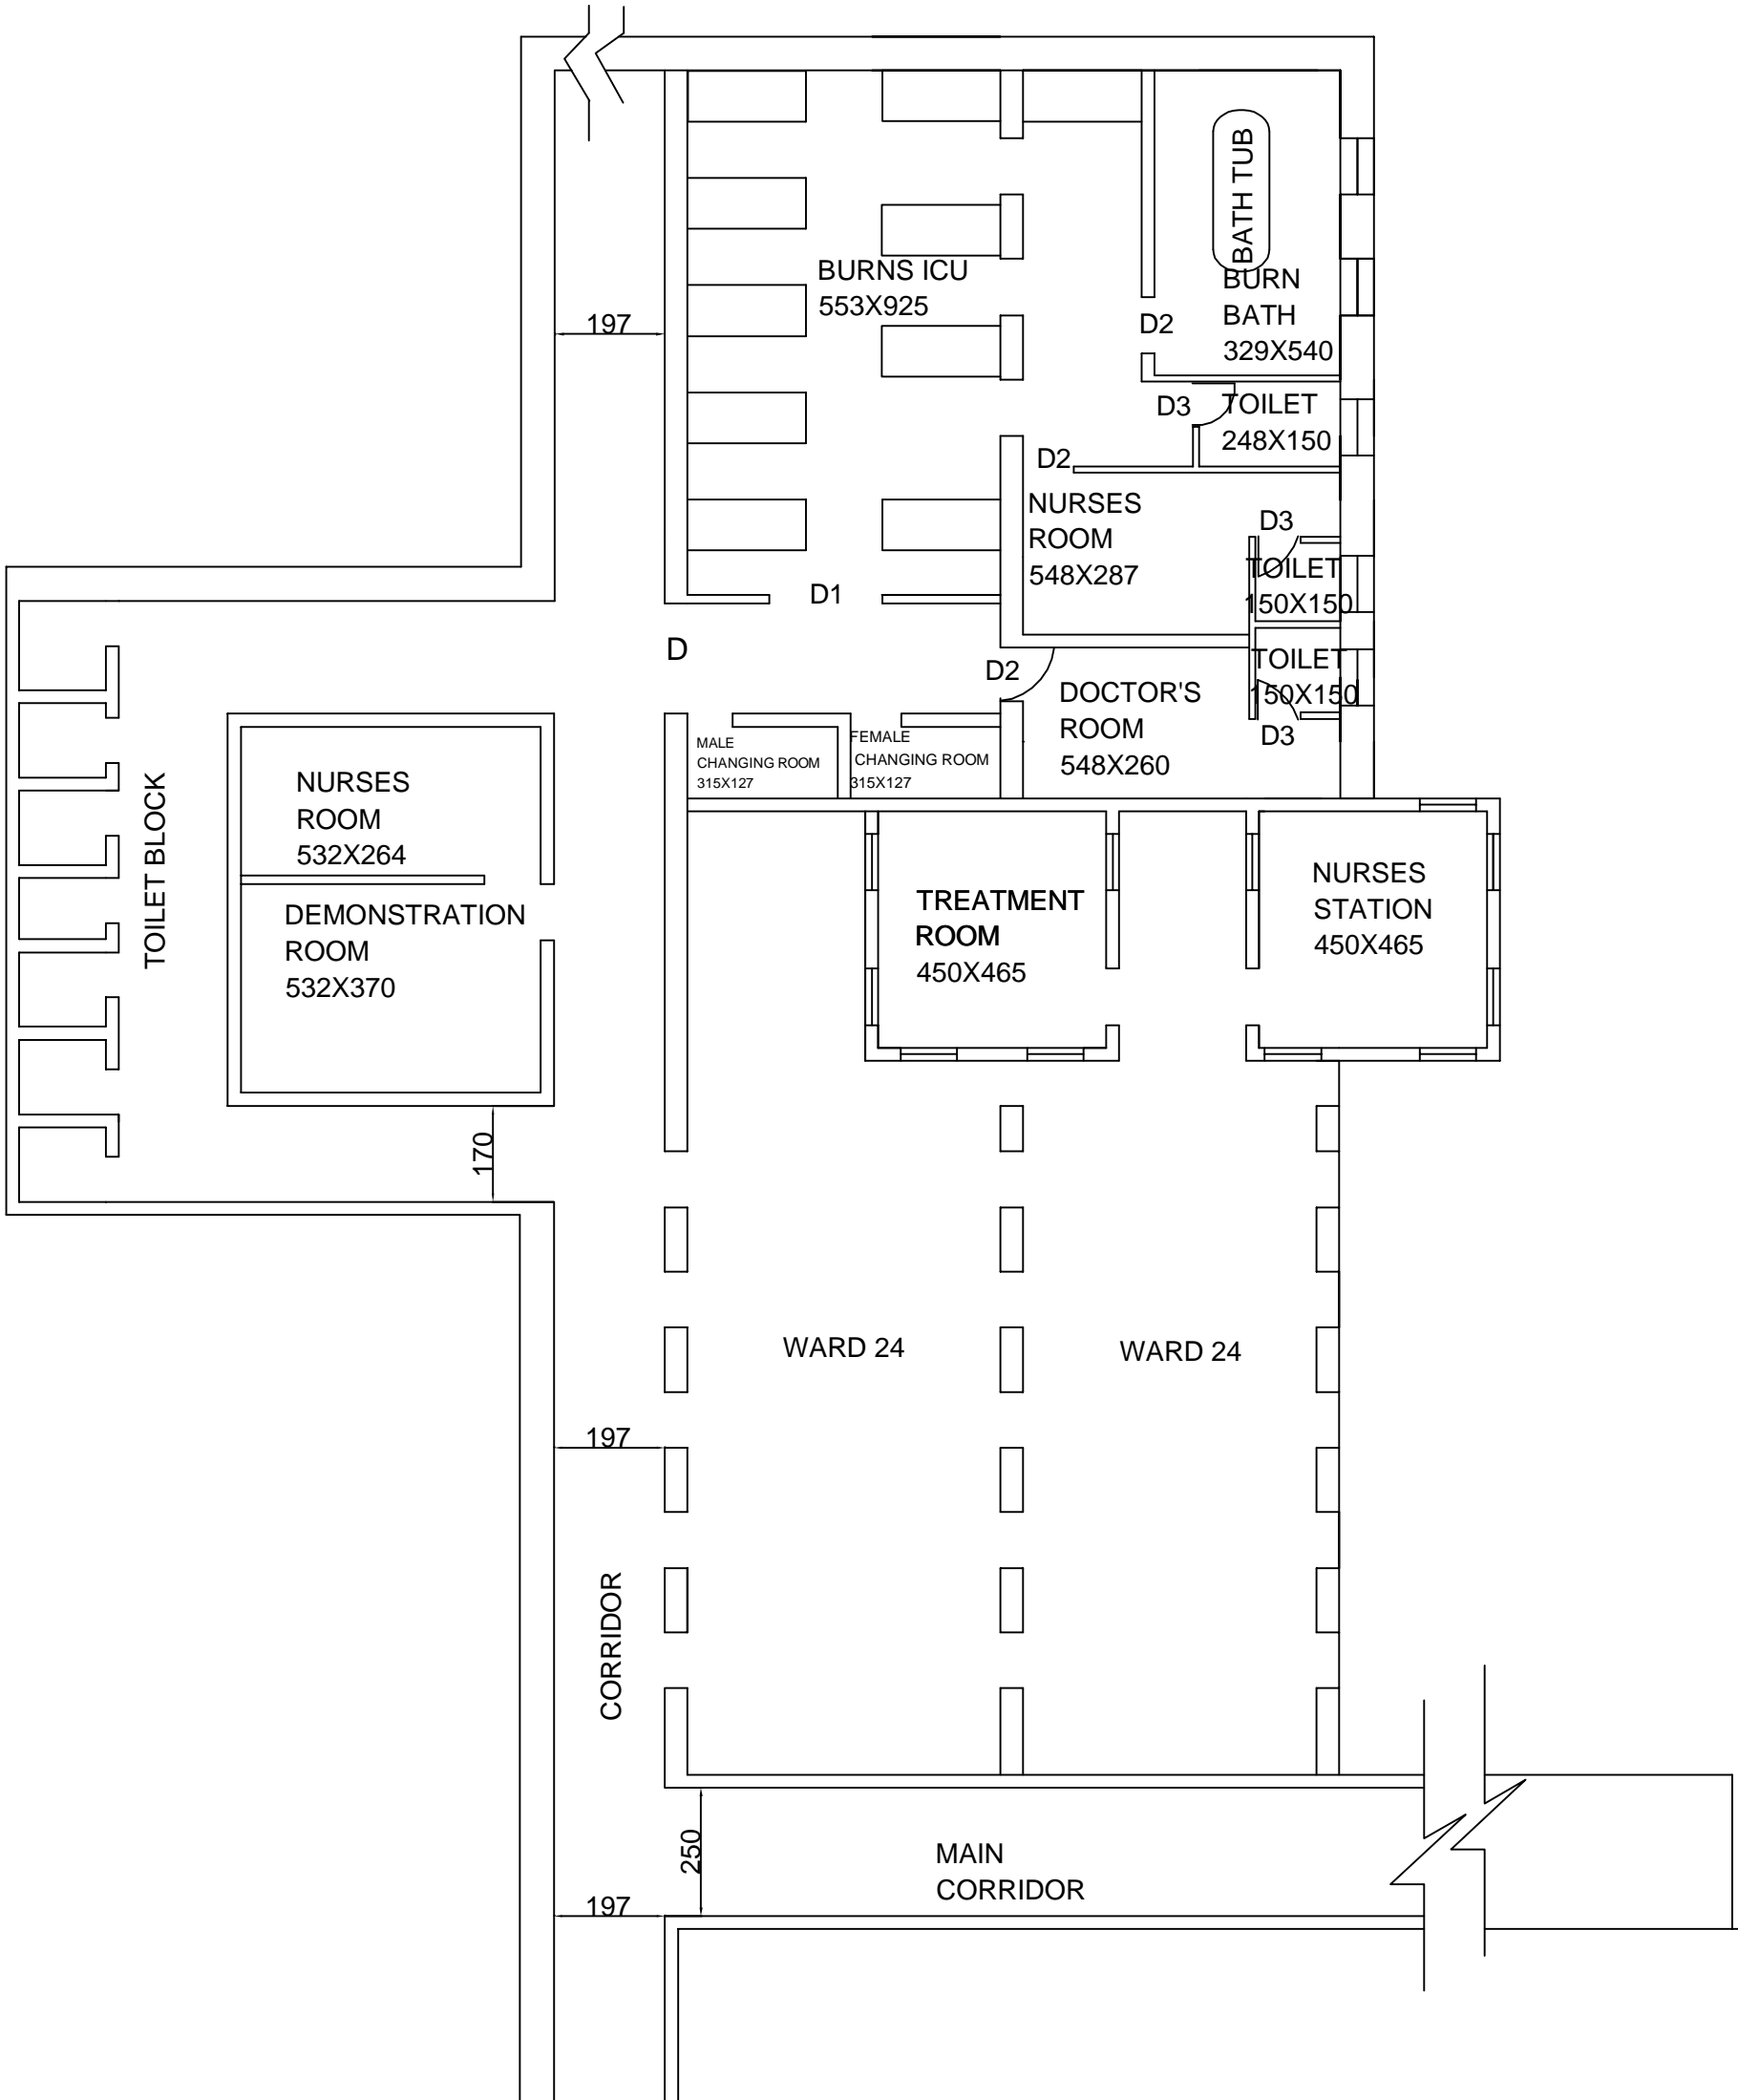

<div>CONSULTANTS:</div> <div></div> <div>H L L LIFE CARE LTD. (A Government of India Enterprise) INFRASTRUCTURE DEVELOPMENT DIVISION VETTAMUKKU THIRUVANANTHAPURAM-6 TEL: 0471-2365872, 2365873 FAX: 0471- 2368144</div>	ARCHITECTURAL DRAWING	PROJECT:- PROPOSED BURNS UNIT IN WARD 24 AT GOVT. MEDICAL COLLEGE , TRIVANDRUM	REVISION	DRAWING NO.	
		DRAWING:- FLOOR PLAN			
		DISCLAIMER : THESE DRAWINGS ARE THE SOLE PROPERTY OF HLL LIFE CARE LTD. NO CHANGES OR COPIES CAN BE MADE WITHOUT CONSENT.		SIGNATURE	