

GENERAL NOTES

LEGEND		
SYMBOL	DETAILS	QTY
	24W TRIM LED TUBELIGHT(WIPRO-LL20)	2
	60W EXHAUST FAN (HAVELLS VENTIL AIR DS)	4
	13W LED SURFACE MOUNTED DOWNLIGHT WIPRO CLEANRAY HALO CRDL11	6
	8W LED SURFACE MOUNTED DOWNLIGHT WIPRO CLEANRAY HALO CRDL11	4
	15W LED BRACKET LIGHT PHILIPS-BWS161	2
	6W 1FEET LED BATTEN(PHILIPS LINEA)	2
	16A SOCKET WITH SWITCH	4
	6A SOCKET WITH SWITCH	6
	COMPUTER SOCKET	3
	SWITCH BOARD	8
	DATA OUTLET	3
	TELEPHONE OUTLET	1
	60W CEILING FAN (HAVELLS MAKE XP-390)	1
	TV POINT	1

FOR CLIENT

ARCHITECT
Habitat
TECHNOLOGY GROUP
POOJAPPURA, THIRUVANANTHAPURAM-12, KERALA, INDIA
habitat@asianerindia.com

PROJECT
**SCIENCE CITY
PALA**

TITLE
ELECTRICAL - AMPHITHEATRE
PROJECTOR ROOM & TOILETS- PHYSICAL LAYOUT

DRAWING STATUS: FOR TENDER PURPOSE

R3	10-3-15	CHANGES INCORPORATED
R2	26-2-15	LUMINAIRE DETAIL INCORPORATED
R1	3-2-15	CHANGES INCORPORATED


REV.	DATE	REMARKS
------	------	---------


DRAWN: ANSY CHECKED: RN APPROVED: NKS


PROJECT NO. 111 DWG NO. AT-E-01 DATE: 29-11-14

ATS CONSULTANTS

Email: atsconsultants@hotmail.com Phone: 0471-4016170/ +91-8714 33 8631

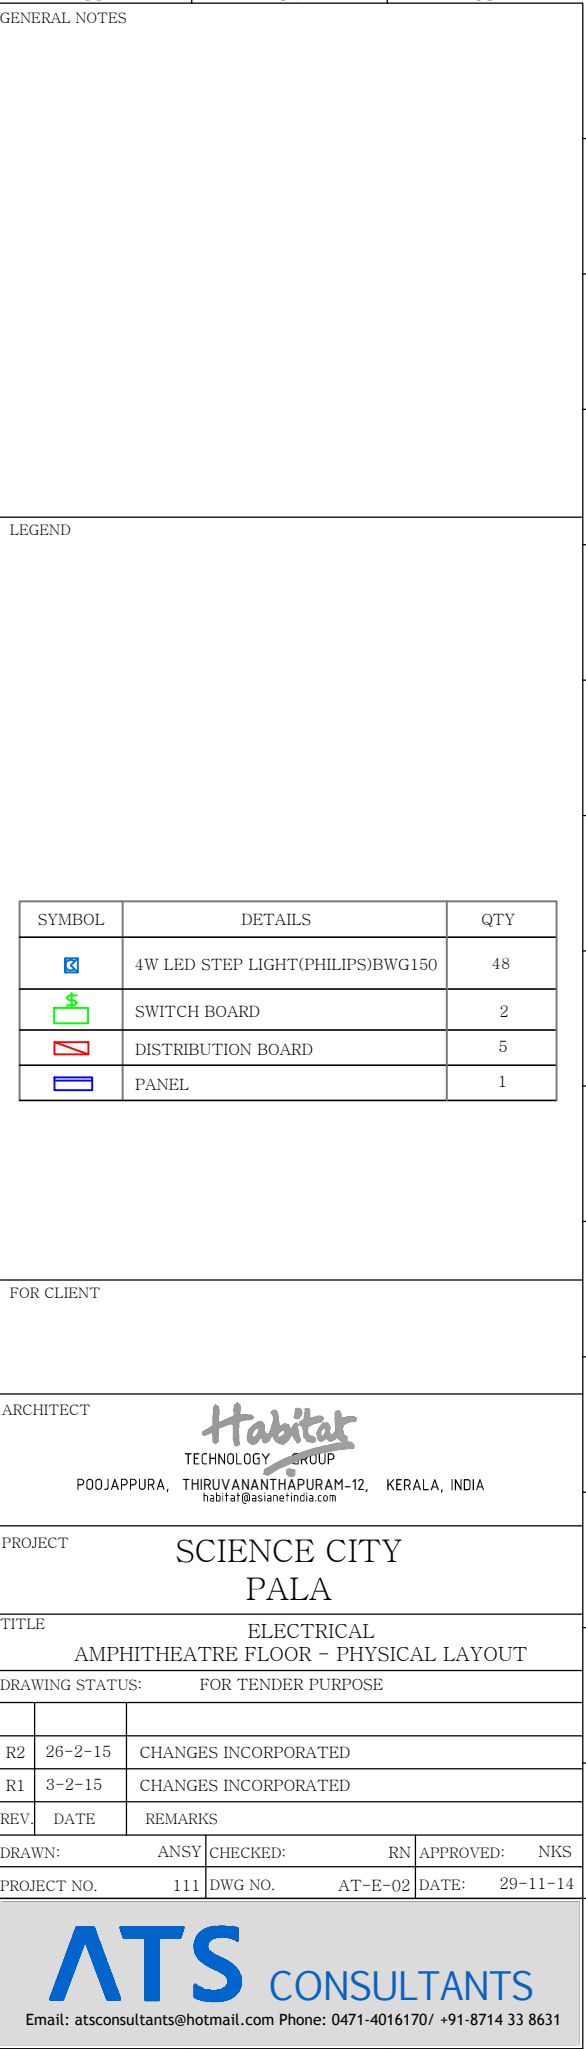

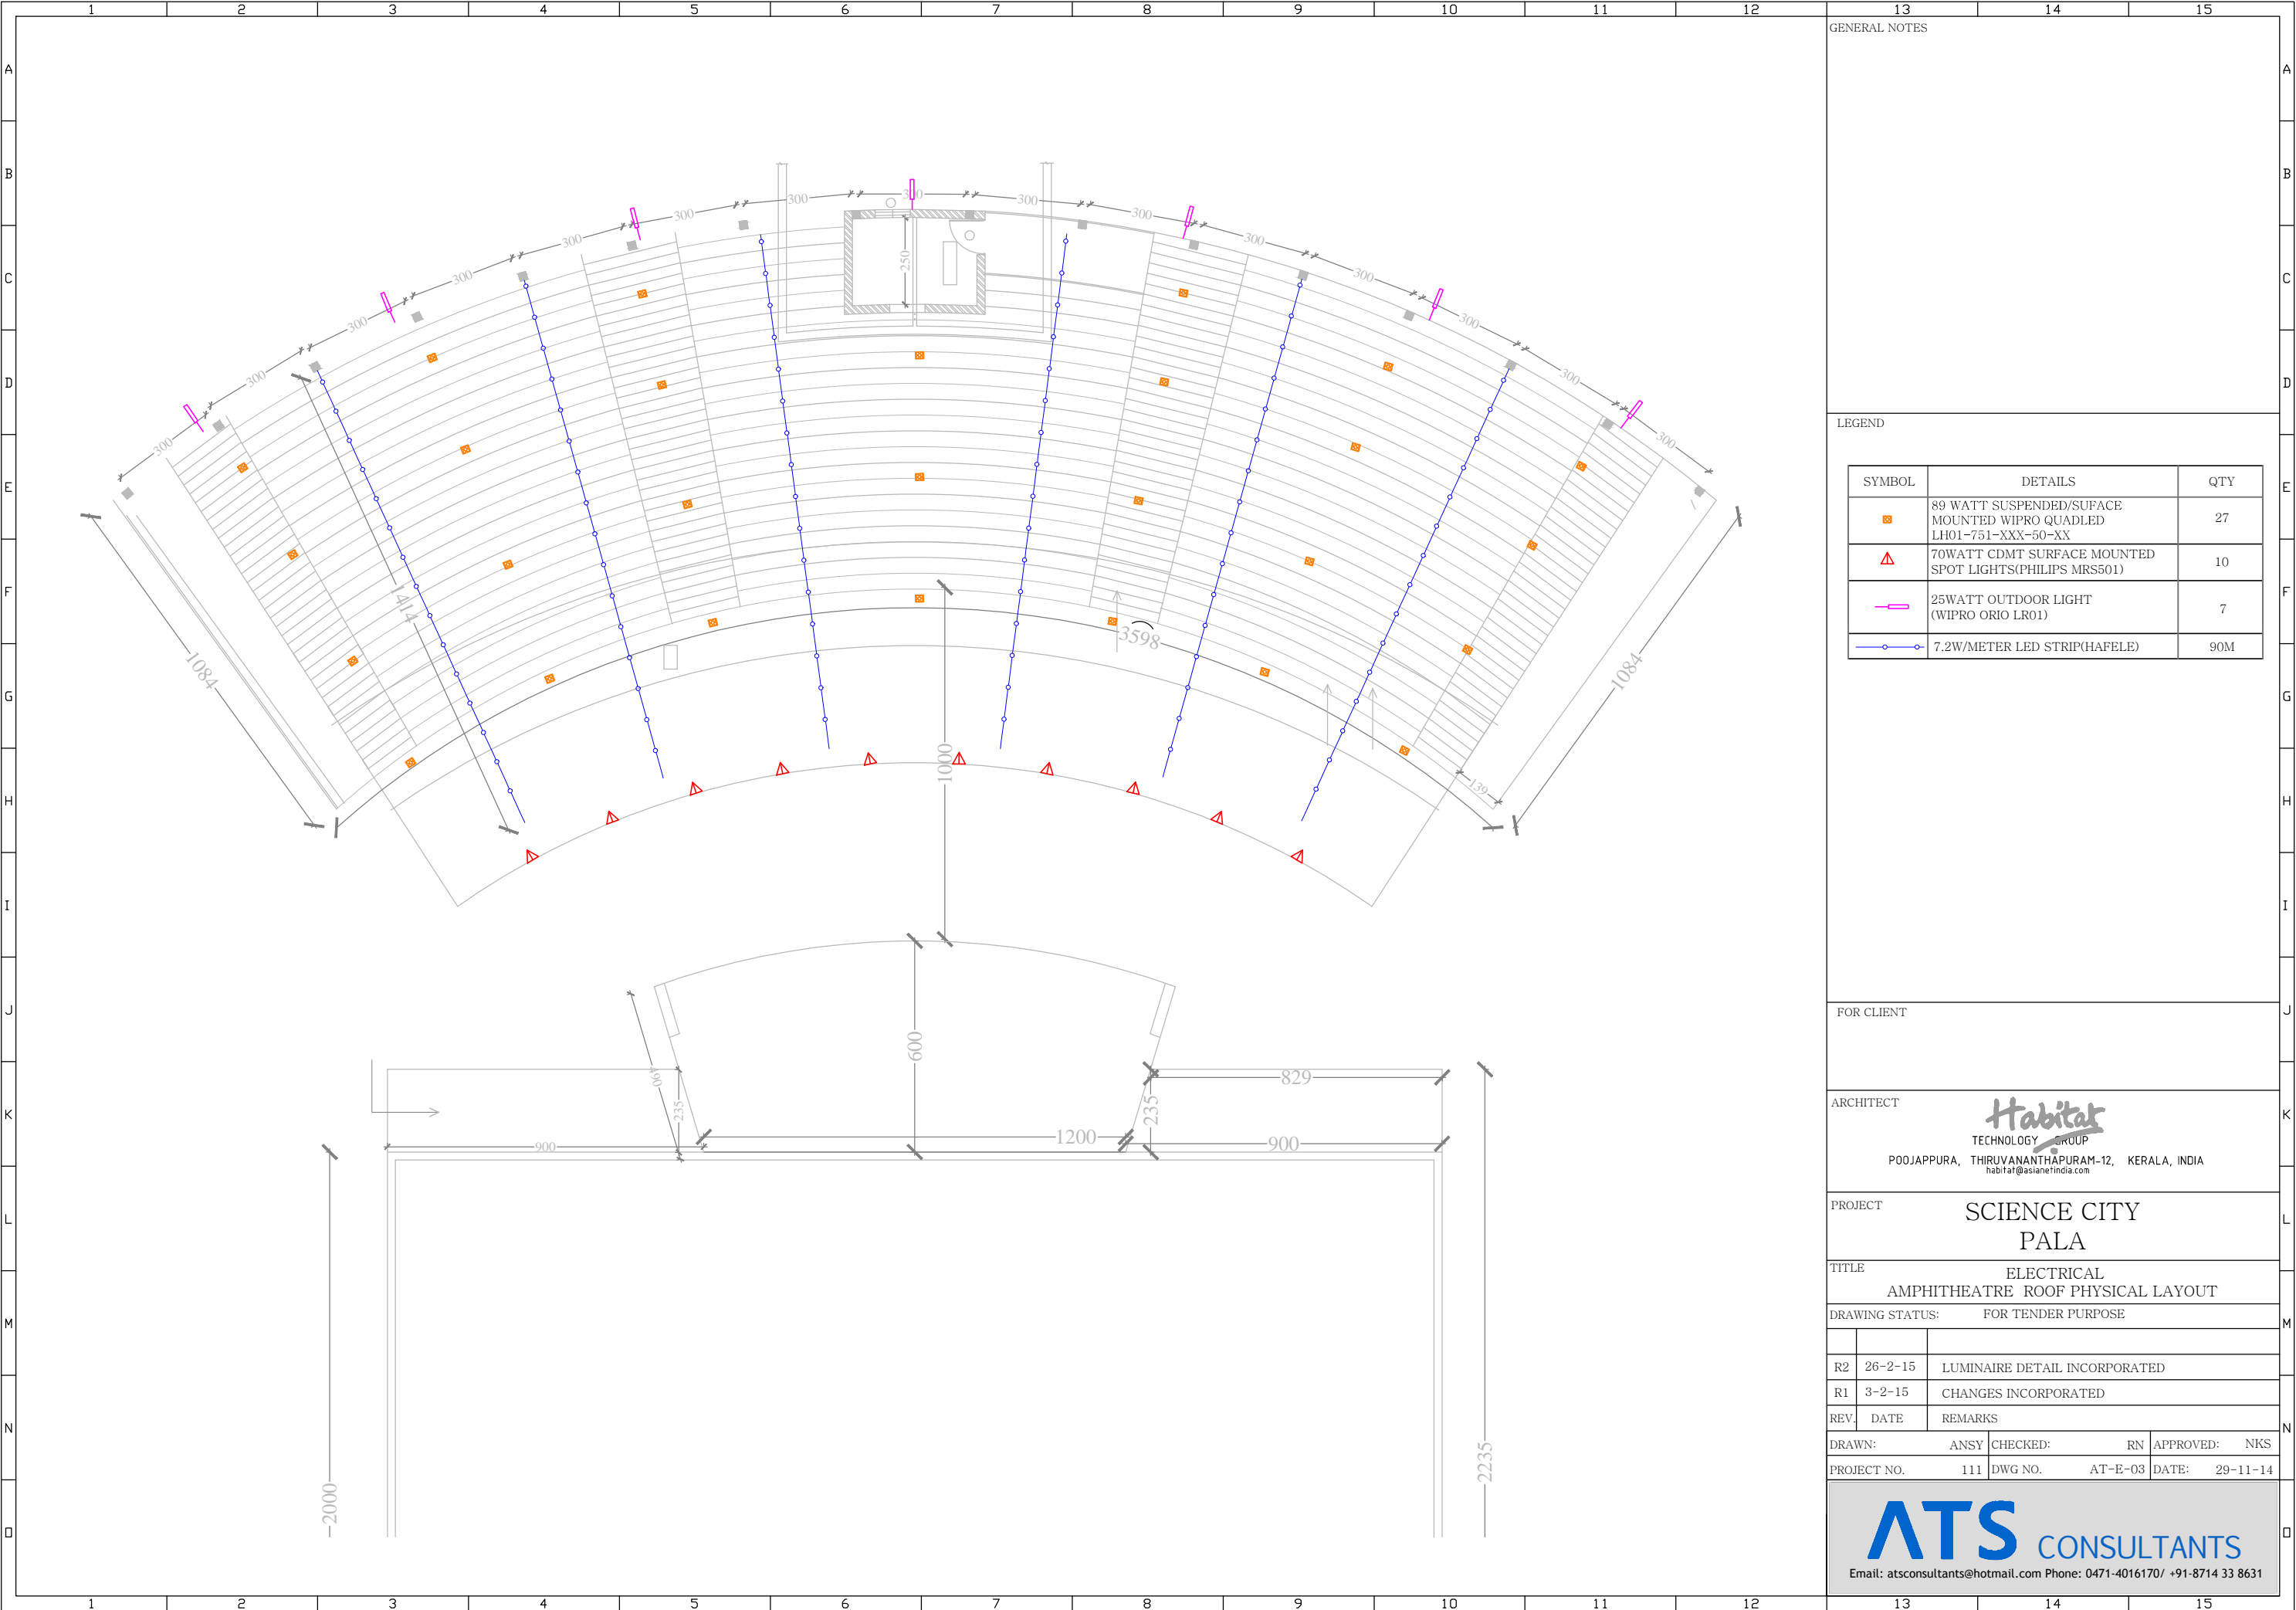

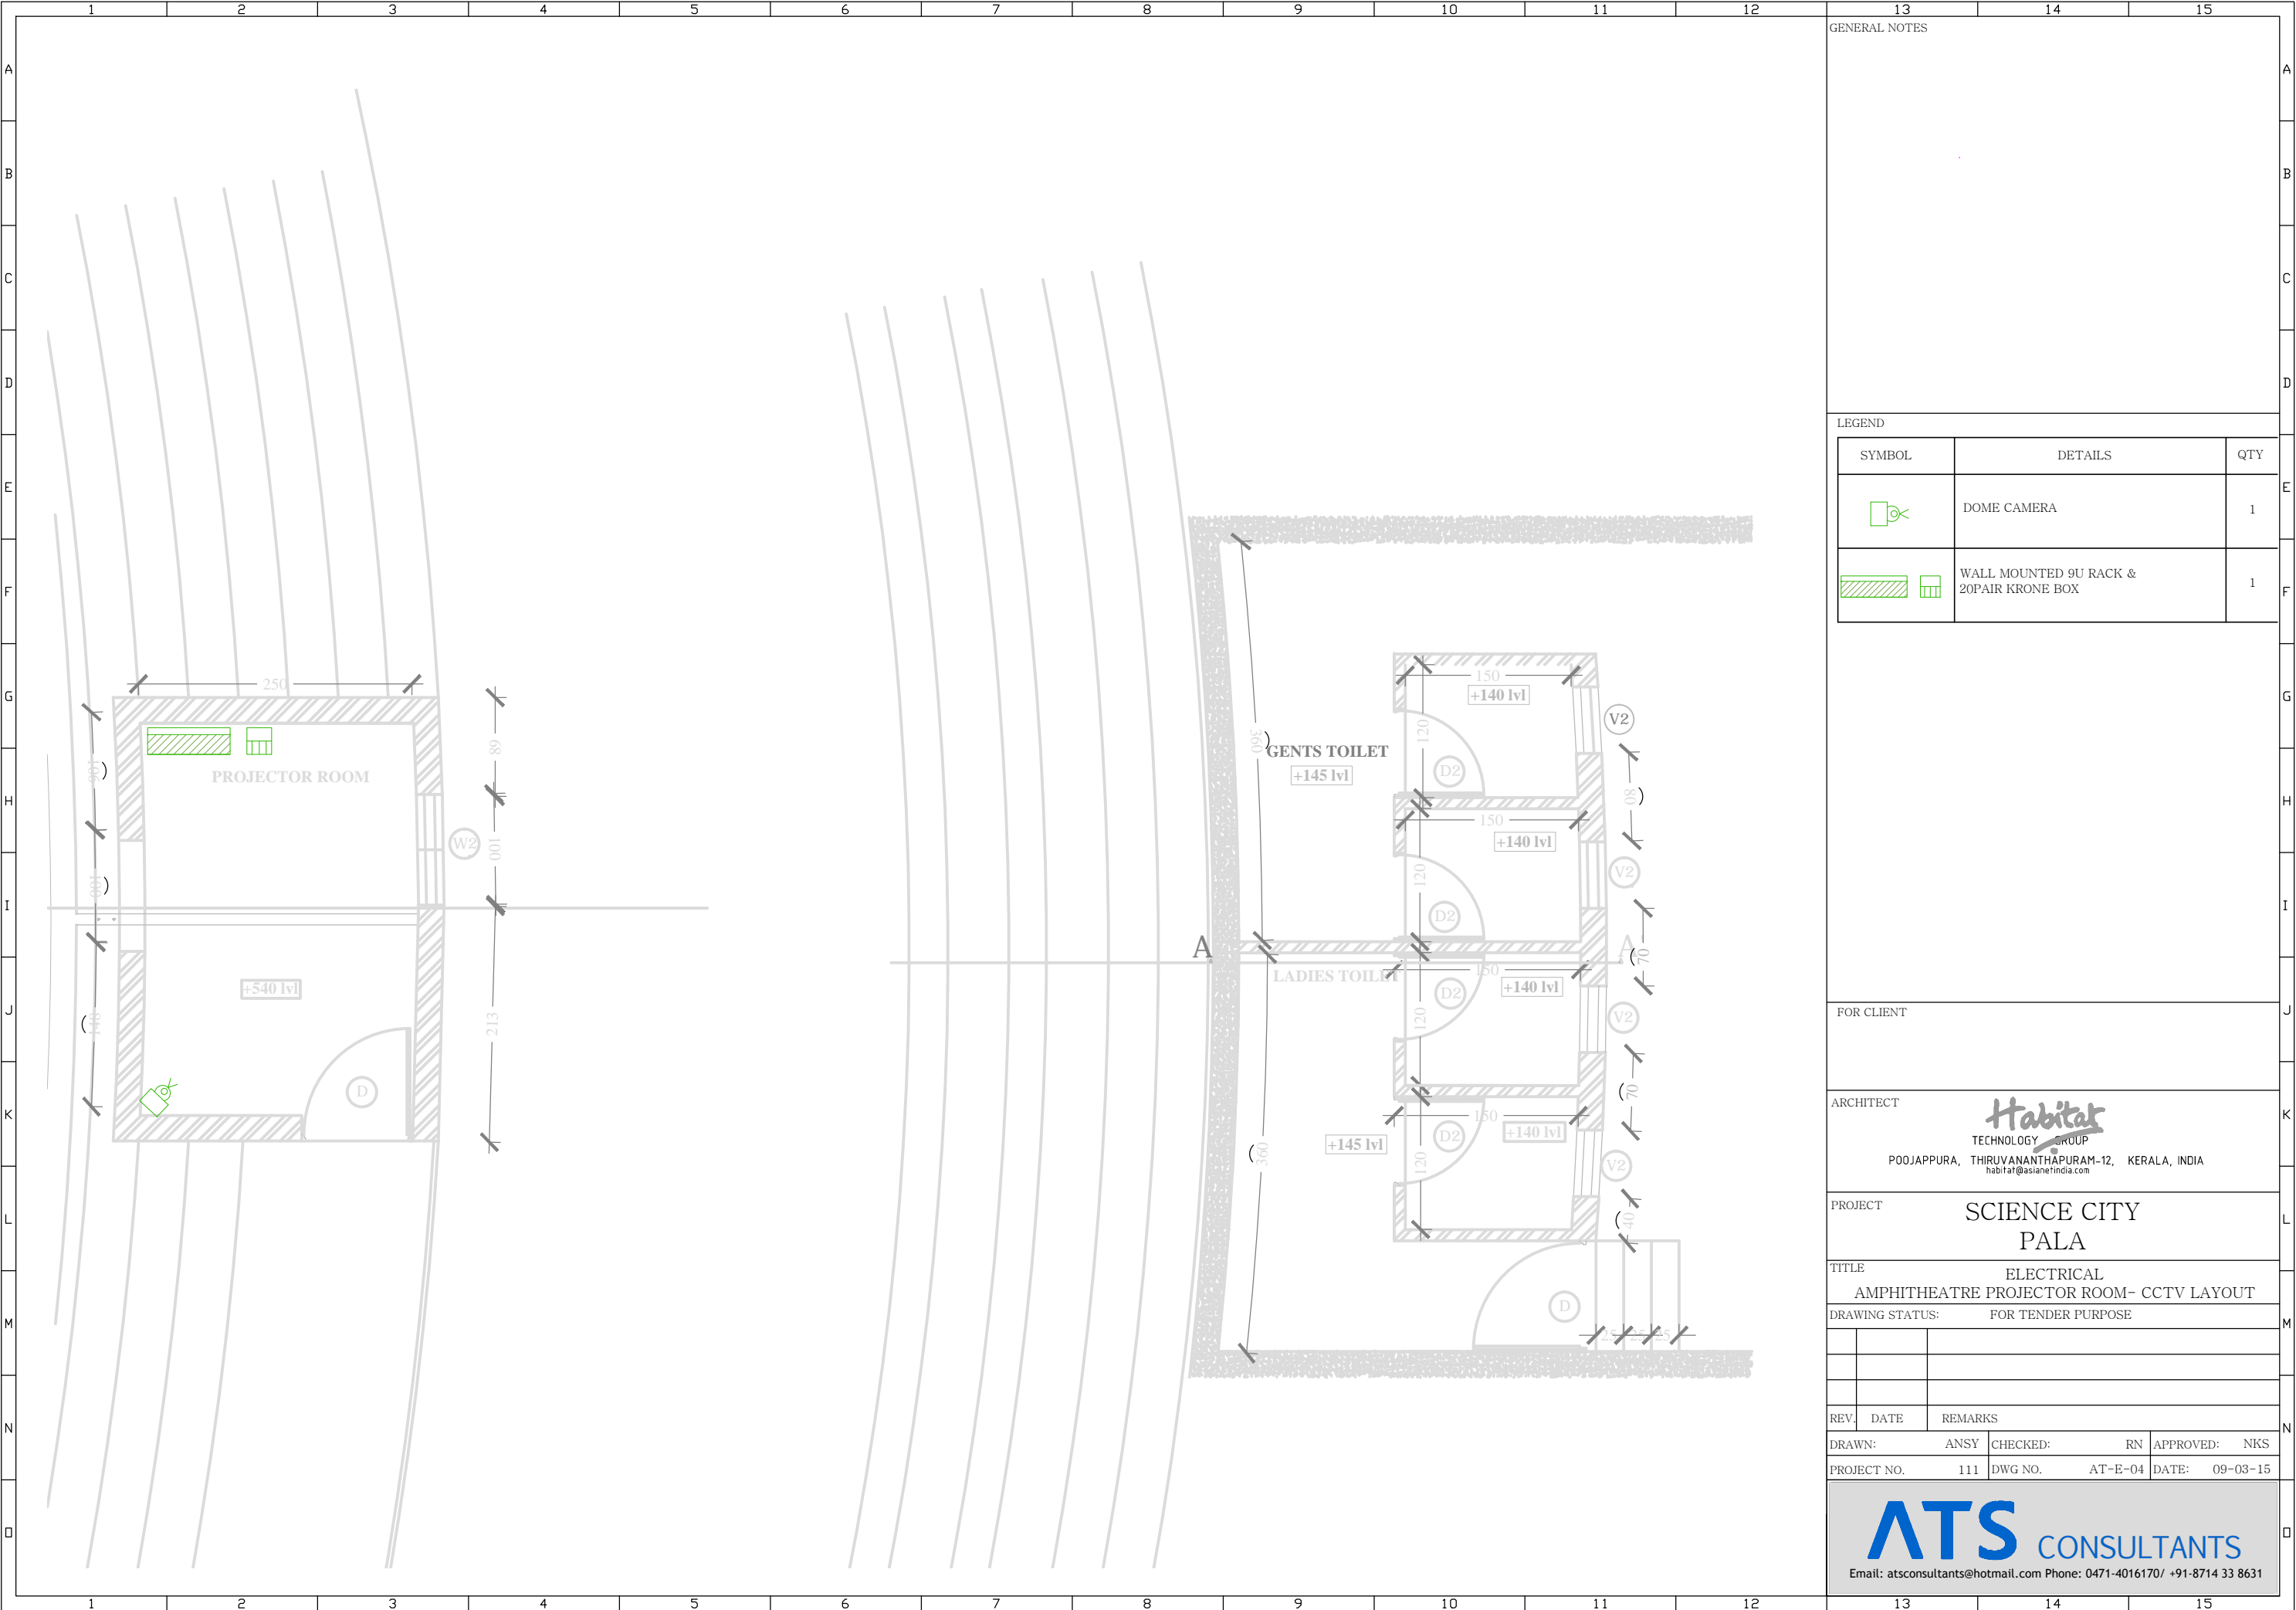



GENERAL NOTES

LEGEND

SYMBOL	DETAILS	QTY
	DOME CAMERA	1
	WALL MOUNTED 9U RACK & 20PAIR KRONE BOX	1

FOR CLIENT

ARCHITECT
Habitat
TECHNOLOGY GROUP
POOJAPPURA, THIRUVANANTHAPURAM-12, KERALA, INDIA
habitat@asianetindia.com

PROJECT
**SCIENCE CITY
PALA**

TITLE
ELECTRICAL
AMPHITHEATRE PROJECTOR ROOM- CCTV LAYOUT

DRAWING STATUS: FOR TENDER PURPOSE

REV.	DATE	REMARKS
DRAWN:	ANSY	CHECKED: RN APPROVED: NKS
PROJECT NO.	111	DWG NO. AT-E-04 DATE: 09-03-15

ATS CONSULTANTS

Email: atsconsultants@hotmail.com Phone: 0471-4016170/ +91-8714 33 8631