
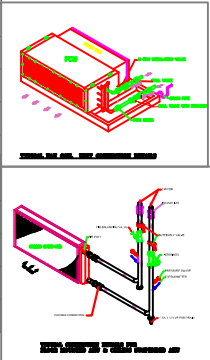


LEGEND		
S.NO	SYMBOL	DISCRIPTION
1		BUTTERFLY VALVE
		PID BALANCING VALVE
		PRESSURE GAUGE
		THARMOMETER
		FLOW SWITCH
		Y-STRAINER
		AIR DIRT SEPARATOR
		CHECK VALVE (NRV)
		FLEXIBLE CONN.
		BALL VALVE
		AIR VENT
		DIRT SEPARATOR

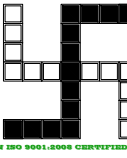

LOWER BASEMENT

TITLE OF DRAWING	
SCHEMATIC CONDENSER AND CHILLED WATER PIPING LAYOUT	
PROJECT Construction of CGHS wellness centre and Administrative Building at R.K.Puram, Sector-13, N.D	
PMC HLL LIFECARE LIMITED ,B-14/A SECTOR -62 NOIDA-201307	
DATE	07-06-2013
DRAWN BY:-	MUSHAHID ALI
CHECKED BY	W.Siddiqui
HVAC & IBMS CONSULTANTS:- LIMRA CONSULTING ENGINEERS 25T SFS FLATS SECTOR-7 JASOLA VIHAR NEW DELHI- 110025 TEL # 911126946981/9810450857 E-MAILS :limrace@rediffmail.com :wsiddiqui21@yahoo.com Website :limraconsultingengineers.com	
ARCHITECT  SKYLINE architectural consultants pvt ltd. architects,engineers & interior designers office : 3rd floor kamal verma commercial complex at patrakar puram crossing gauti nagar Roa U.P. INDIA delhi : 0222-2394123,2393123,4044123 fax 0222-2393128 email : sk@sk@skyline.com,architect@skyline315@gmail.com website : www.skylinearchitect.com chgo office : 48107 WOODMICHIGAN TECH DRIVE SUITE-6 WOODMICHIGAN MICHIGAN, USA - 48393 TEL : (248)975-1200/FAX (248)975-1201 AN ISO 9001:2008 CERTIFIED architect : sanjay & vijay sinha	

TENDER DRAWING

HVAC REVISIONS

SL. NO.	DESCRIPTION	BY	DATE
1	REVISED AS PER NEW ARCH.PLAN	T.R.K	19.03.2013
2	REVISED AS PER NEW ARCH.PLAN	MUSHAHID	15.05.2013
3	REVISED AS PER NEW ARCH.PLAN	MUSHAHID	23.05.2013

HVAC & IBMS CONSULTANTS:-

LIMRA CONSULTING ENGINEERS

25T SFS FLATS SECTOR-7
JASOLA VIHAR NEW DELHI- 110025
TEL # 911126946981/9810450857
E-MAILS :limrace@rediffmail.com
:wsiddiqui21@yahoo.com
Website :-limraconsultingengineers.com



PROJECT
Construction of CGHS wellness centre and
Administrative Building at R.K.Puram, Sector-13, New Delhi

PMC
HLL LIFECARE LIMITED ,B-14/A
SECTOR -62
NOIDA-201307


ARCHITECT



SKYLINE
architectural consultants pvt ltd.
architects,engineers & interior designers
office : 3rd floor laxmi vandan commercial complex at
pankaj puram crossing gauri nagar Ro L.P.INDIA
dial : 0522-2394123,2393123,4044123 fax: 0522-2393126
email : skyline@usaiboc.com,architectskyline315@gmail.com
website : www.skylinearchitect.com
asso office : 49187 WIKOM TECH DRIVE SUITE 8 WIKOM MICHIGAN
MICHIGAN,USA - 48935 TEL : (248)975 1200 FAX (248)975 1201
architect : sanjay & vijay sinha

TITLE	SCALE - N.T.S.	DATE
LOWER BASEMENT AC PLANT ROOM & VENTILATION LAYOUT	PRPD. BY VINOD CHKD. BY W.SIDDHARTH APPRVD. BY	12.03.2013 12.03.2013

DRAWING NO.	HLL R.K. PURAM /HVAC-01	REV.
SHEET NO.		R-0

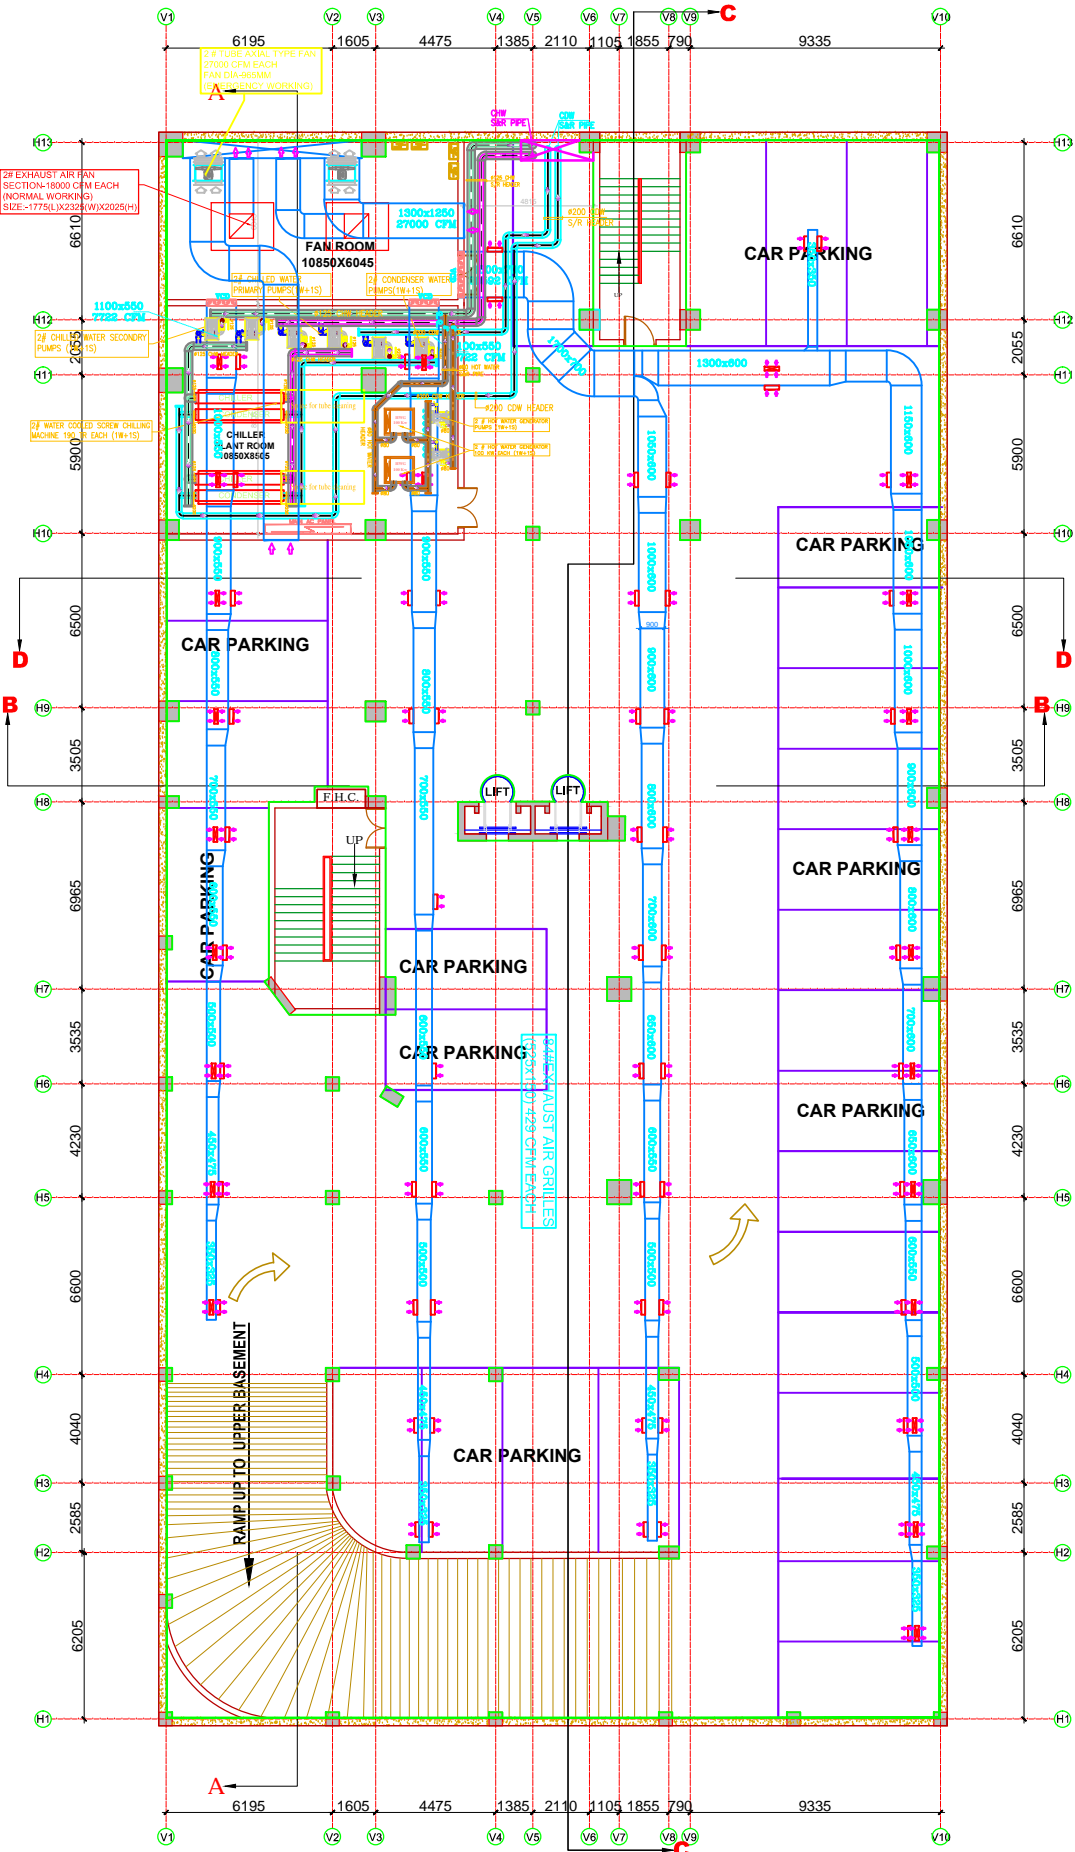

LOWER BASEMENT PLAN
(GRID 1mx1m)

TENDER DRAWING

HVAC REVISIONS

SL. NO.	DESCRIPTION	BY	DATE
1	REVISED AS PER NEW ARCH. PLAN	T.R.K	12.04.2013
2	REVISED AS PER NEW ARCH. PLAN	MUSHAHID	15.05.2013
3	REVISED AS PER NEW ARCH. PLAN	MUSHAHID	23.05.2013

HVAC & IBMS CONSULTANTS:-

LIMRA CONSULTING ENGINEERS

25T SFS FLATS SECTOR-7
JASOLA VIHAR NEW DELHI- 110025
TEL # 911126946981/9810450857
E-MAILS :limrace@rediffmail.com
:wsiddiqui21@yahoo.com
Website :-limraconsultingengineers.com



PROJECT
Construction of CGHS wellness centre and
Administrative Building at R.K.Puram, Sector-13, New Delhi


PMC
HLL LIFECARE LIMITED ,B-14/A
SECTOR -62
NOIDA-201307

ARCHITECT

SKYLINE
architectural consultants pvt ltd.
architects,engineers & interior designers
office : 1st floor, laxmi vardan commercial complex at
pankaj puram crossing gauri nagar, Sec 13, U.P. INDIA
skid : 0522-2394123,2393123,4044123 fax: 0522-2393126
email : skyline@satish.com,architectskylines@gmail.com
website : www.skylinearchitect.com
asso office : 49187 WILSON TECH DRIVE SUITE 8 WILSON MICHIGAN
MICHIGAN, USA - 48393 TEL : (248)975 1200 FAX (248)975 1201
architect : sanjay & vijay sinha
AN ISO 9001:2008 CERTIFIED


TITLE	SCALE - N.T.S.	DATE
UPPER BASEMENT VENTILATION LAYOUT	PRPD. BY VINOOD CHKD. BY W.SIDDQUI APPRD. BY	12.03.2013 12.03.2013

DRAWING NO.	HLL R.K. PURAM /HVAC-02	REV.
SHEET NO.		R-0

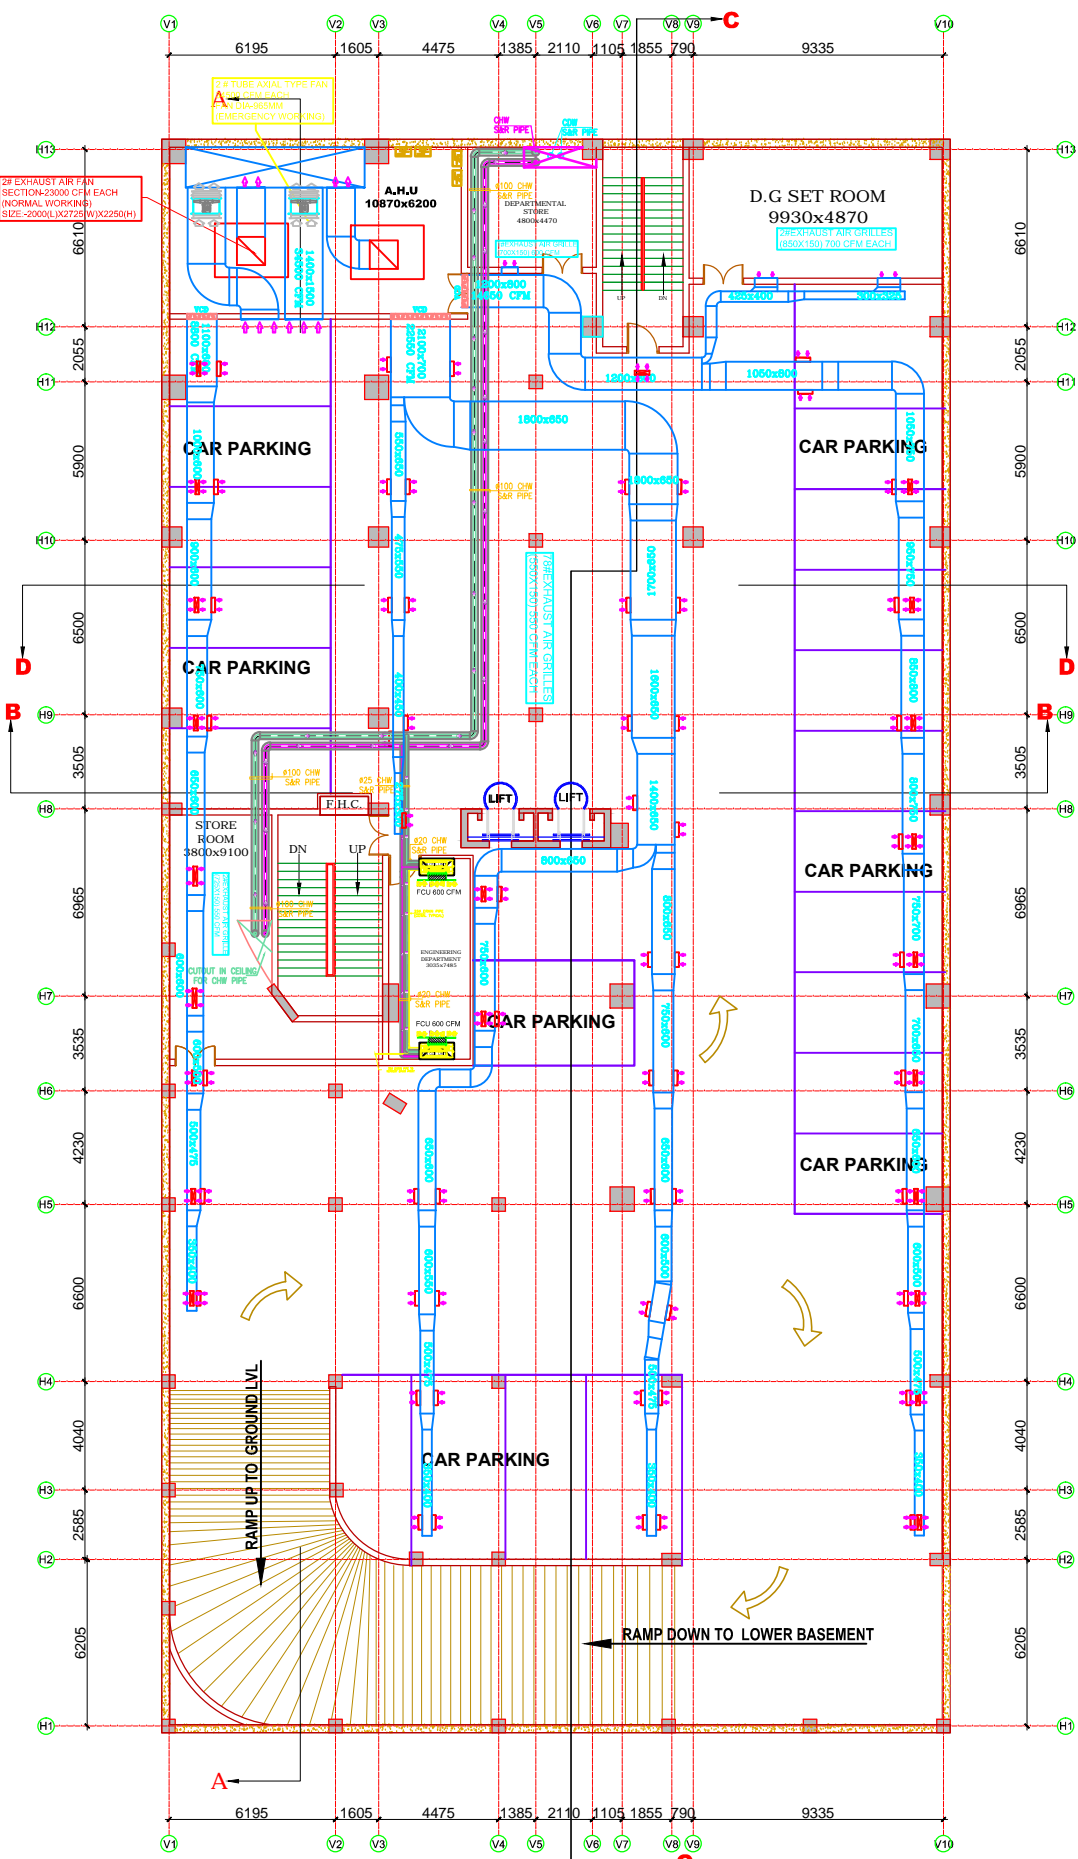

UPPER BASEMENT PLAN
(GRID 1mx1m)

TENDER DRAWING

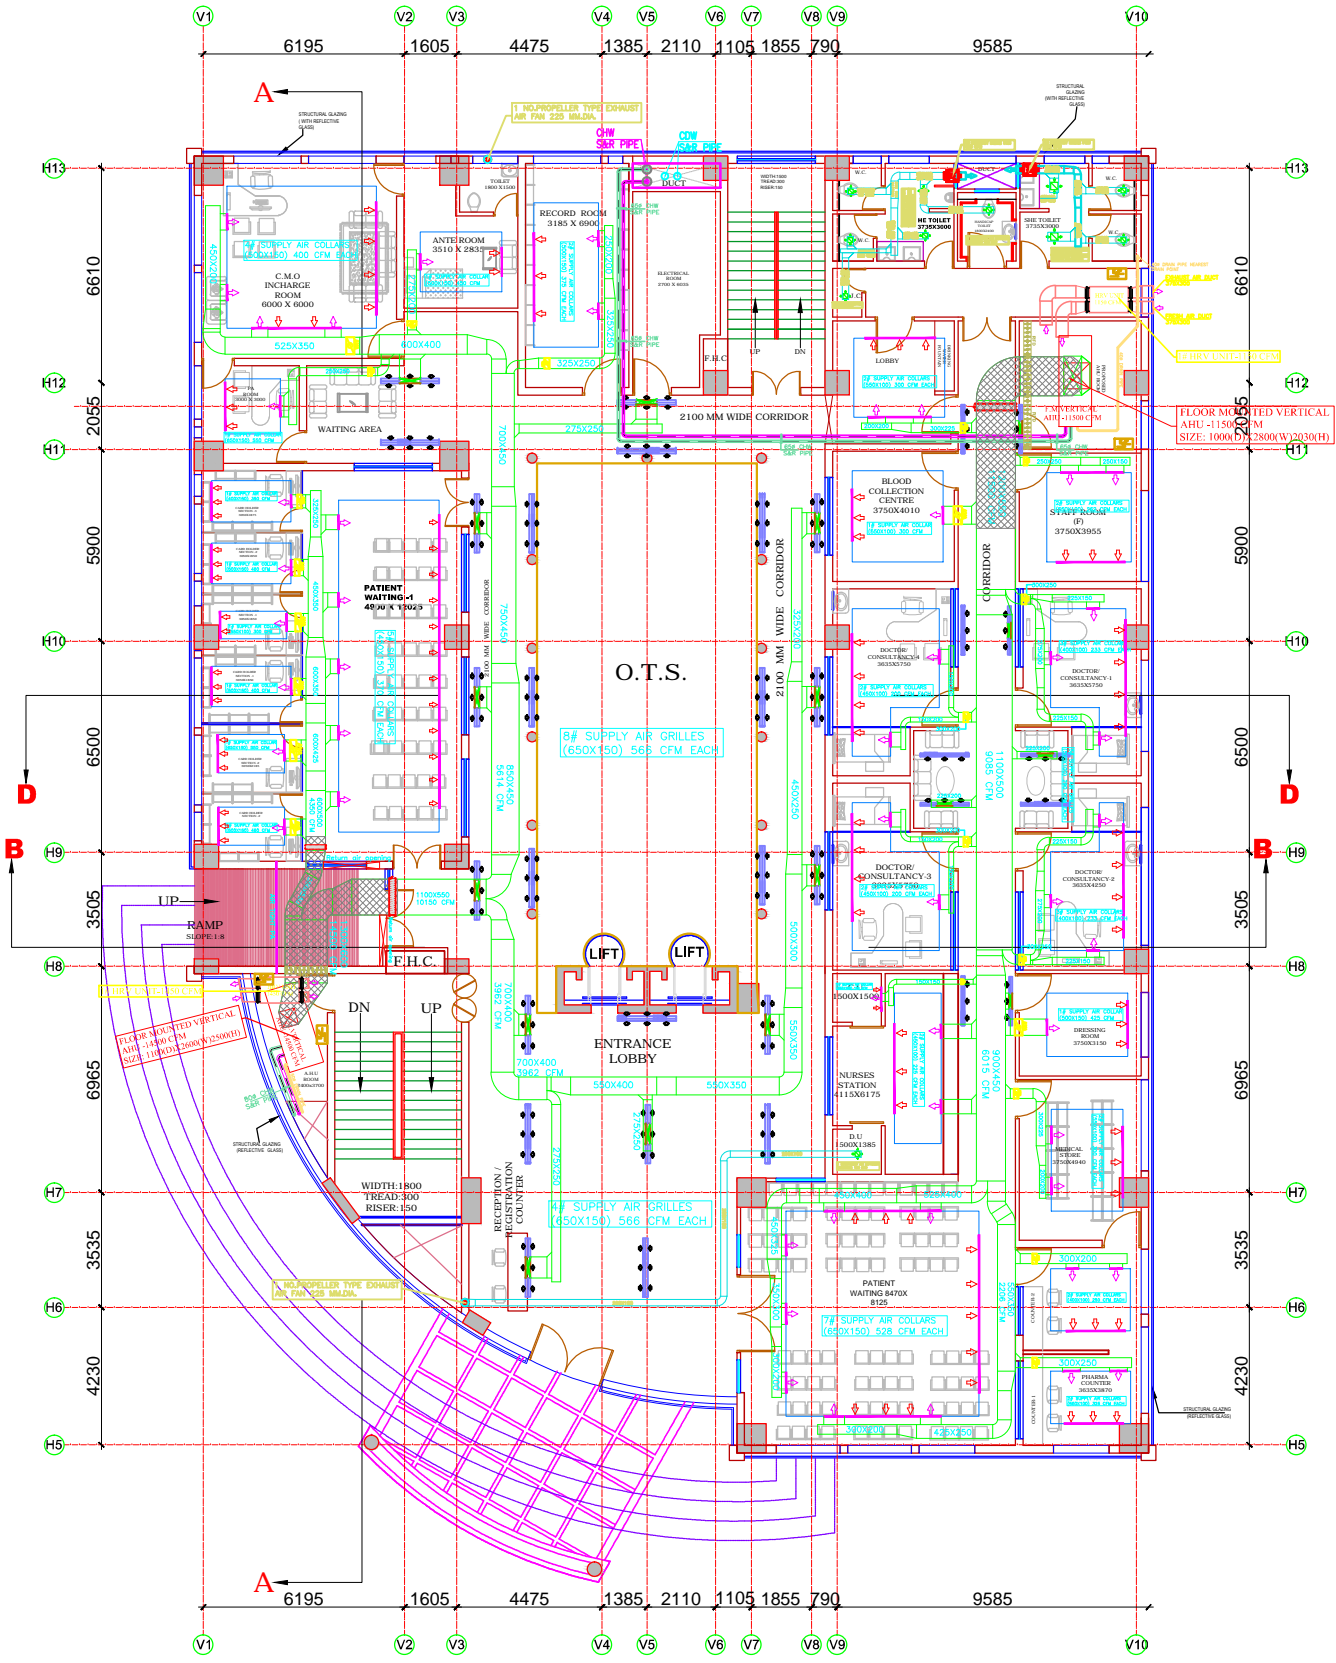

GROUND FLOOR HVAC PLAN

HVAC REVISIONS

SL. NO.	DESCRIPTION	BY	DATE
1	REVISED AS PER NEW ARCH.PLAN	T.R.K	12.04.2013
2	REVISED AS PER NEW ARCH.PLAN	MUSHAHID	12.05.2013
3	REVISED AS PER NEW ARCH.PLAN	MUSHAHID	23.05.2013

HVAC & IBMS CONSULTANTS:-
LIMRA CONSULTING ENGINEERS
25T SFS FLATS SECTOR-7
JASOLA VIHAR NEW DELHI- 110025
TEL # 911126946981/9810450857
E-MAILS :limrace@rediffmail.com
:wsiddiqui21@yahoo.com
Website :-limraconsultingengineers.com



PROJECT
Construction of CGHS wellness centre and
Administrative Building at R.K.Puram, Sector-13, New Delhi

PMC
HLL LIFECARE LIMITED ,B-14/A
SECTOR -62
NOIDA-201307


ARCHITECT

SKYLINE
architectural consultants pvt ltd.
architects,engineers & interior designers
office : 3rd floor karni vardan commercial complex at
pankaj puram crossing gauri nagar Sec 13 P.INDIA
tel : 0522-2394123,2393123,4044123 fax: 0522-2393126
email : skyline@vsnl.com,architectskline@gmail.com
website : www.skylinearchitect.com
asso office : 49187 WIKOM TECH DRIVE SUITE 8 WIKOM MICHIGAN
MICHIGAN, USA - 48303 TEL : (248)975-1200 FAX (248)975-1201
architect : sanjay & vijay sinha
AN ISO 9001:2008 CERTIFIED

TITLE	SCALE - N.T.S.	DATE
GROUND FLOOR HVAC LAYOUT	PRP'D. BY T.R.K	12.03.13
	CHKD. BY W.SIDDQUI	12.03.13
	APPR'D. BY	

DRAWING NO.	HLL R.K. PURAM /HVAC-03	REV.
SHEET NO.		R-0

TENDER DRAWING

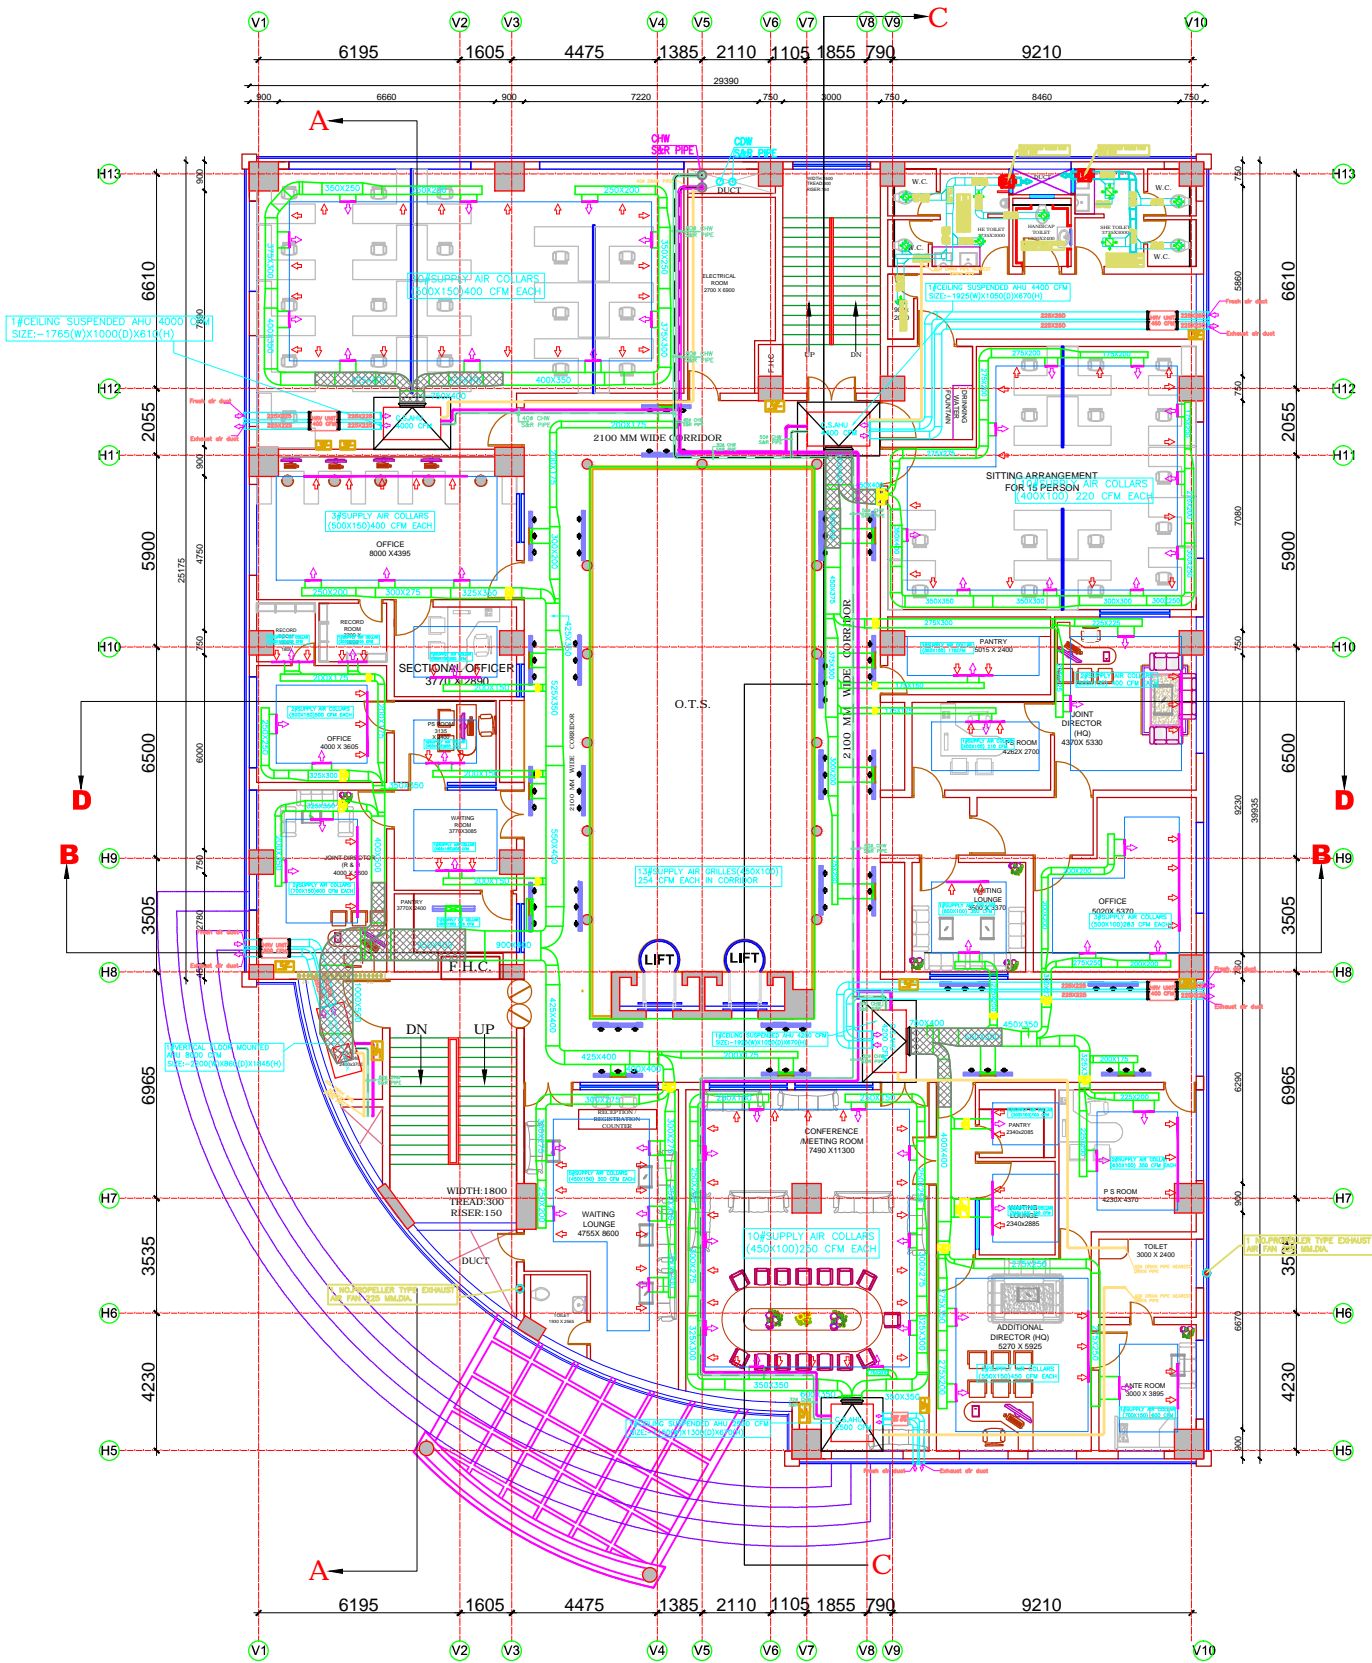

FIRST FLOOR HVAC LAYOUT

HVAC REVISIONS

SL. NO.	DESCRIPTION	BY	DATE
1	REVISED AS PER NEW ARCH. PLAN	T.R.K	12.04.2013
2	REVISED AS PER NEW ARCH. PLAN	MUSHAHID	15.05.2013
3	REVISED AS PER NEW ARCH. PLAN	MUSHAHID	23.05.2013

HVAC & IBMS CONSULTANTS:-

LIMRA CONSULTING ENGINEERS


25T SFS FLATS SECTOR-7
JASOLA VIHAR NEW DELHI- 110025
TEL # 911126946981/9810450857
E-MAILS :limrace@rediffmail.com
:wsiddiqui21@yahoo.com
Website :-limraconsultingengineers.com



PROJECT
Construction of CGHS wellness centre and
Administrative Building at R.K.Puram, Sector-13, New Delhi

PMC
HLL LIFECARE LIMITED ,B-14/A
SECTOR -62
NOIDA-201307

ARCHITECT




SKYLINE
architectural consultants pvt ltd.
architects,engineers & interior designers
office : 1st floor laxmi vandan commercial complex at
pankaj puram crossing gauri nagar Sec 13 U.P. INDIA
tele : 0522-2394123,2393123,4044123 fax: 0522-2393126
email : skyline@vsnl.com,architectskyline@gmail.com
website : www.skylinearchitect.com
asso office : 49187 WIKOM TECH DRIVE SUITE 8 WIKOM MICHIGAN
MICHIGAN, USA - 48935 TEL : (248)975-1200 FAX (248)975-1201
architect : sanjay & vijay sinha

TITLE	SCALE - N.T.S.	DATE
FIRST FLOOR HVAC LAYOUT	PRPD. BY VINOD CHKD. BY W.SIDDQUI APPRD. BY	12.03.2013 12.03.2013

DRAWING NO.	HLL R.K. PURAM /HVAC-04	REV.
SHEET NO.		R-0

TENDER DRAWING

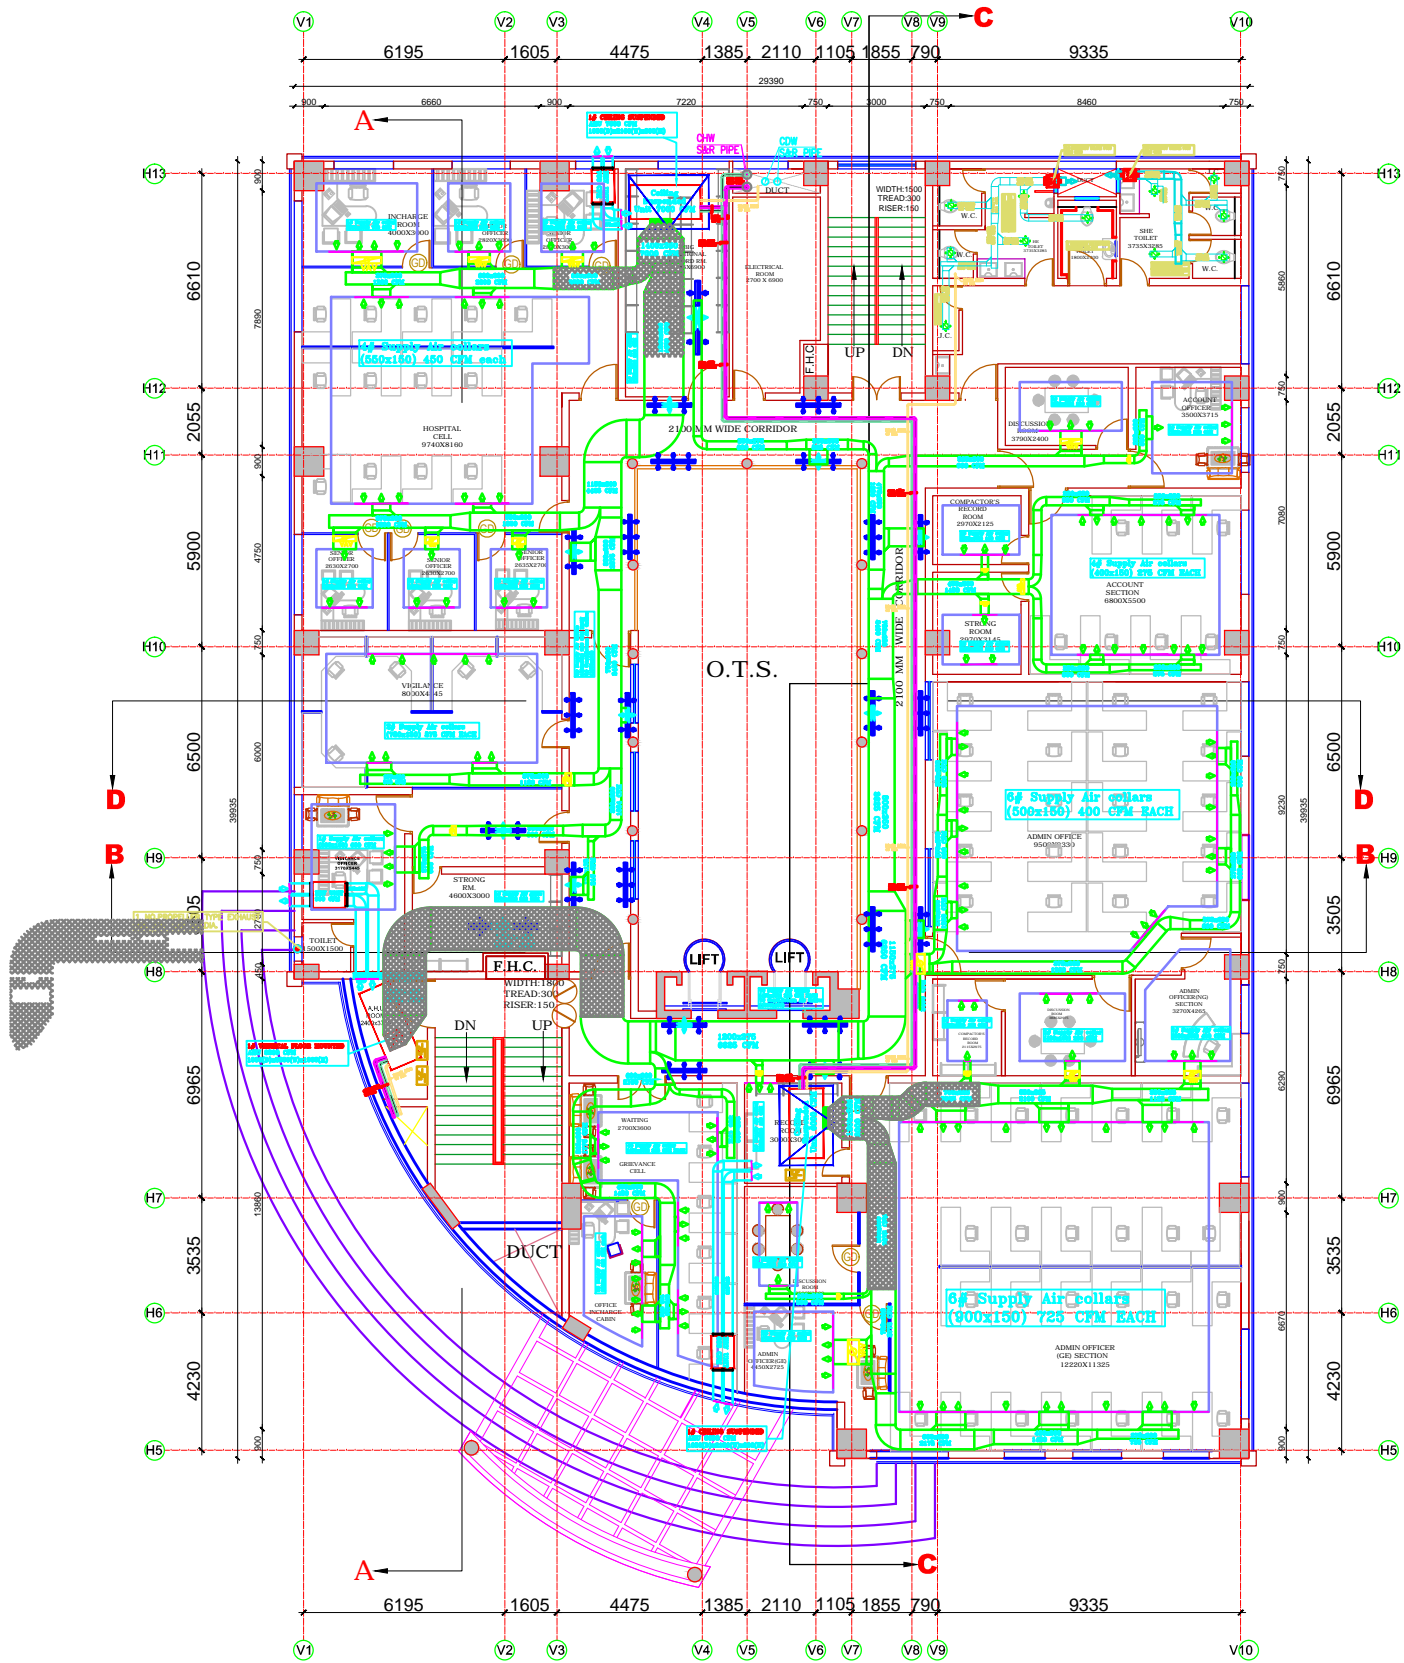

SECOND FLOOR HVAC PLAN

HVAC REVISIONS

SL. NO.	DESCRIPTION	BY	DATE
1	REVISED AS PER NEW ARCH.PLAN	T.R.K	12.04.2013
2	REVISED AS PER NEW ARCH.PLAN	MUSHAHID	15.05.2013
3	REVISED AS PER NEW ARCH.PLAN	MUSHAHID	23.05.2013

HVAC & IBMS CONSULTANTS:-
LIMRA CONSULTING ENGINEERS
25T SFS FLATS SECTOR-7
JASOLA VIHAR NEW DELHI- 110025
TEL # 911126946981/9810450857
E-MAILS :limrace@rediffmail.com
:wsiddiqui21@yahoo.com
Website :-limraconsultingengineers.com

PROJECT
Construction of CGHS wellness centre and
Administrative Building at R.K.Puram, Sector-13, New Delhi

PMC
HLL LIFECARE LIMITED ,B-14/A
SECTOR -62
NOIDA-201307


ARCHITECT

SKYLINE
architectural consultants pvt ltd.
architects,engineers & interior designers
office : 3rd floor laxmi vandan commercial complex at
pankaj puram crossing gurgaon road Sec 13 P.N.D.A.
tel : 0522-2394123,2393123,4044123 fax: 0522-2393126
email : skyline@usahoc.com,architectskyline315@gmail.com
website : www.skylinearchitect.com
asso office : 49187 WIKOM TECH DRIVE SUITE 8 WIKOM MICHIGAN
MICHIGAN, USA - 48935 TEL : (248)975-1200 FAX (248)975-1201
architect : sanjay & vijay sinha
AN ISO 9001:2008 CERTIFIED

TITLE	SCALE - N.T.S.	DATE
SECOND FLOOR HVAC LAYOUT	PRPD. BY MUSHAHID CHKD. BY W.SIDDIQUI APPRVD. BY	12.03.2013 12.03.2013

DRAWING NO.	HLL R.K. PURAM /HVAC -05	REV.
SHEET NO.		R-0

TENDER DRAWING

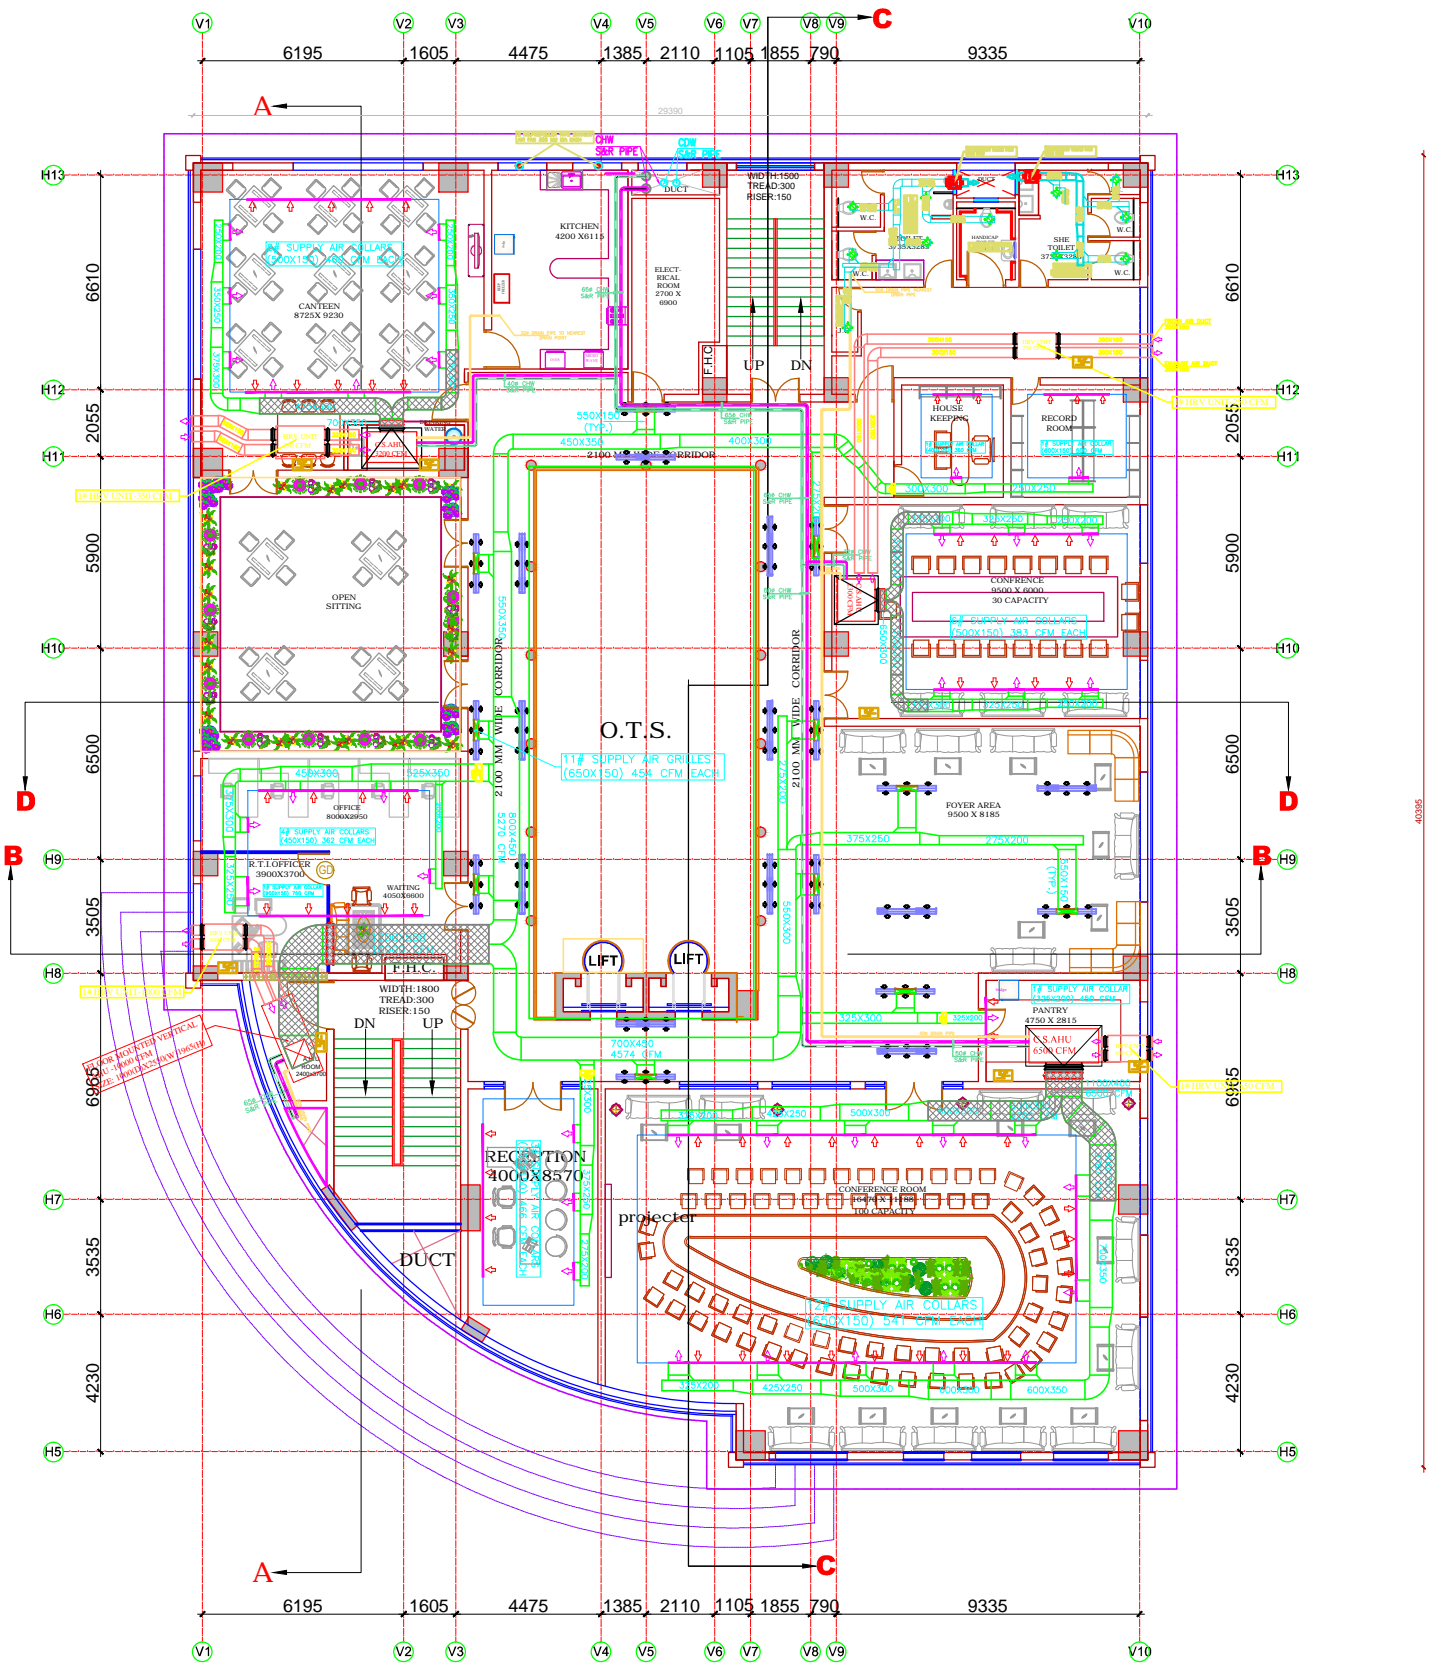

THIRD FLOOR HVAC PLAN

HVAC REVISIONS

SL. NO.	DESCRIPTION	BY	DATE
1	REVISED AS PER NEW ARCH.PLAN	T.R.K	12.04.2013
2	REVISED AS PER NEW ARCH.PLAN	MUSHAHID	12.05.2013
3	REVISED AS PER NEW ARCH.PLAN	MUSHAHID	23.05.2013

HVAC & IBMS CONSULTANTS:-
LIMRA CONSULTING ENGINEERS
25T SFS FLATS SECTOR-7
JASOLA VIHAR NEW DELHI- 110025
TEL # 911126946981/9810450857
E-MAILS :limrace@rediffmail.com
:wsiddiqui21@yahoo.com
Website :-limraconsultingengineers.com

PROJECT
Construction of CGHS wellness centre and
Administrative Building at R.K.Puram, Sector-13, New Delhi

PMC
HLL LIFECARE LIMITED ,B-14/A
SECTOR -62
NOIDA-201307

ARCHITECT
SKYLINE
architectural consultants pvt ltd.
architects,engineers & interior designers
office : 3rd floor karni vardan commercial complex at
pankaj puram crossing gauri nagar Ro L.P.INDIA
skid : 0822-2394123,2393123,4044123 fax: 0522-2393126
email : skyline@usahoc.com,architectskylines15@gmail.com
website : www.skylinearchitect.com
asso office : 49187 WIKOM TECH DRIVE SUITE 8 WIKOM MICHIGAN
MICHIGAN,USA - 48393 TEL: (248)975 1200/FAX (248)975 1201
architect : sanjay & vijay sinha
AN ISO 9001:2008 CERTIFIED

TITLE	SCALE - N.T.S.	DATE
THIRD FLOOR HVAC LAYOUT	PRPD. BY T.R.K CHKD. BY W.SIDDQUI APPRD. BY	12.03.13 12.03.13

DRAWING NO.	HLL R.K. PURAM /HVAC-06	REV.
SHEET NO.		R-0

TENDER DRAWING

HVAC REVISIONS

SL. NO.	DESCRIPTION	BY	DATE
1	REVISED AS PER NEW ARCH.PLAN	T.R.K	12.04.2013
2	REVISED AS PER NEW ARCH.PLAN	MUSHAHID	12.05.2013
3	REVISED AS PER NEW ARCH.PLAN	MUSHAHID	23.05.2013

HVAC & IBMS CONSULTANTS:-

LIMRA CONSULTING ENGINEERS

25T SFS FLATS SECTOR-7
JASOLA VIHAR NEW DELHI- 110025
TEL # 911126946981/9810450857
E-MAILS :limrace@rediffmail.com
:wsiddiqui21@yahoo.com
Website :-limraconsultingengineers.com



PROJECT

Construction of CGHS wellness centre and
Administrative Building at R.K.Puram, Sector-13, New Delhi

PMC

HLL LIFECARE LIMITED ,B-14/A
SECTOR -62
NOIDA-201307

ARCHITECT

SKYLINE

architectural consultants pvt ltd.
architects,engineers & interior designers
office : 3rd floor karni vardan commercial complex at
pankaj puram crossing gauri nagar Roj L.P. INDIA
dial : 0522-2394123,2393123,4044123 fax: 0522-2393126
email : skyline@usahoc.com,architectskyline315@gmail.com
website : www.skylinearchitect.com
asso office : 49187 WIKOM TECH DRIVE SUITE 8 WIKOM MICHIGAN
MICHIGAN, USA - 48393 TEL : (248)975 1200/FAX (248)975 1201
architect : sanjay & vijay sinha

AN ISO 9001:2008 CERTIFIED

TITLE	SCALE - N.T.S.	DATE
TERRACE FLOOR HVAC LAYOUT	PREP. BY T.R.K	12.03.13
	CHECK. BY W.SIDDIQUI	12.03.13
	APPROVED BY	

DRAWING NO.	HLL R.K. PURAM /HVAC-07	REV.
SHEET NO.		R-0

TERRACE FLOOR HVAC LAYOUT