



KEY PLAN  
NTS

LEGEND	
	MAN HOLE
	GULLY TRAP
	110uPVC, SLOPE 1:70

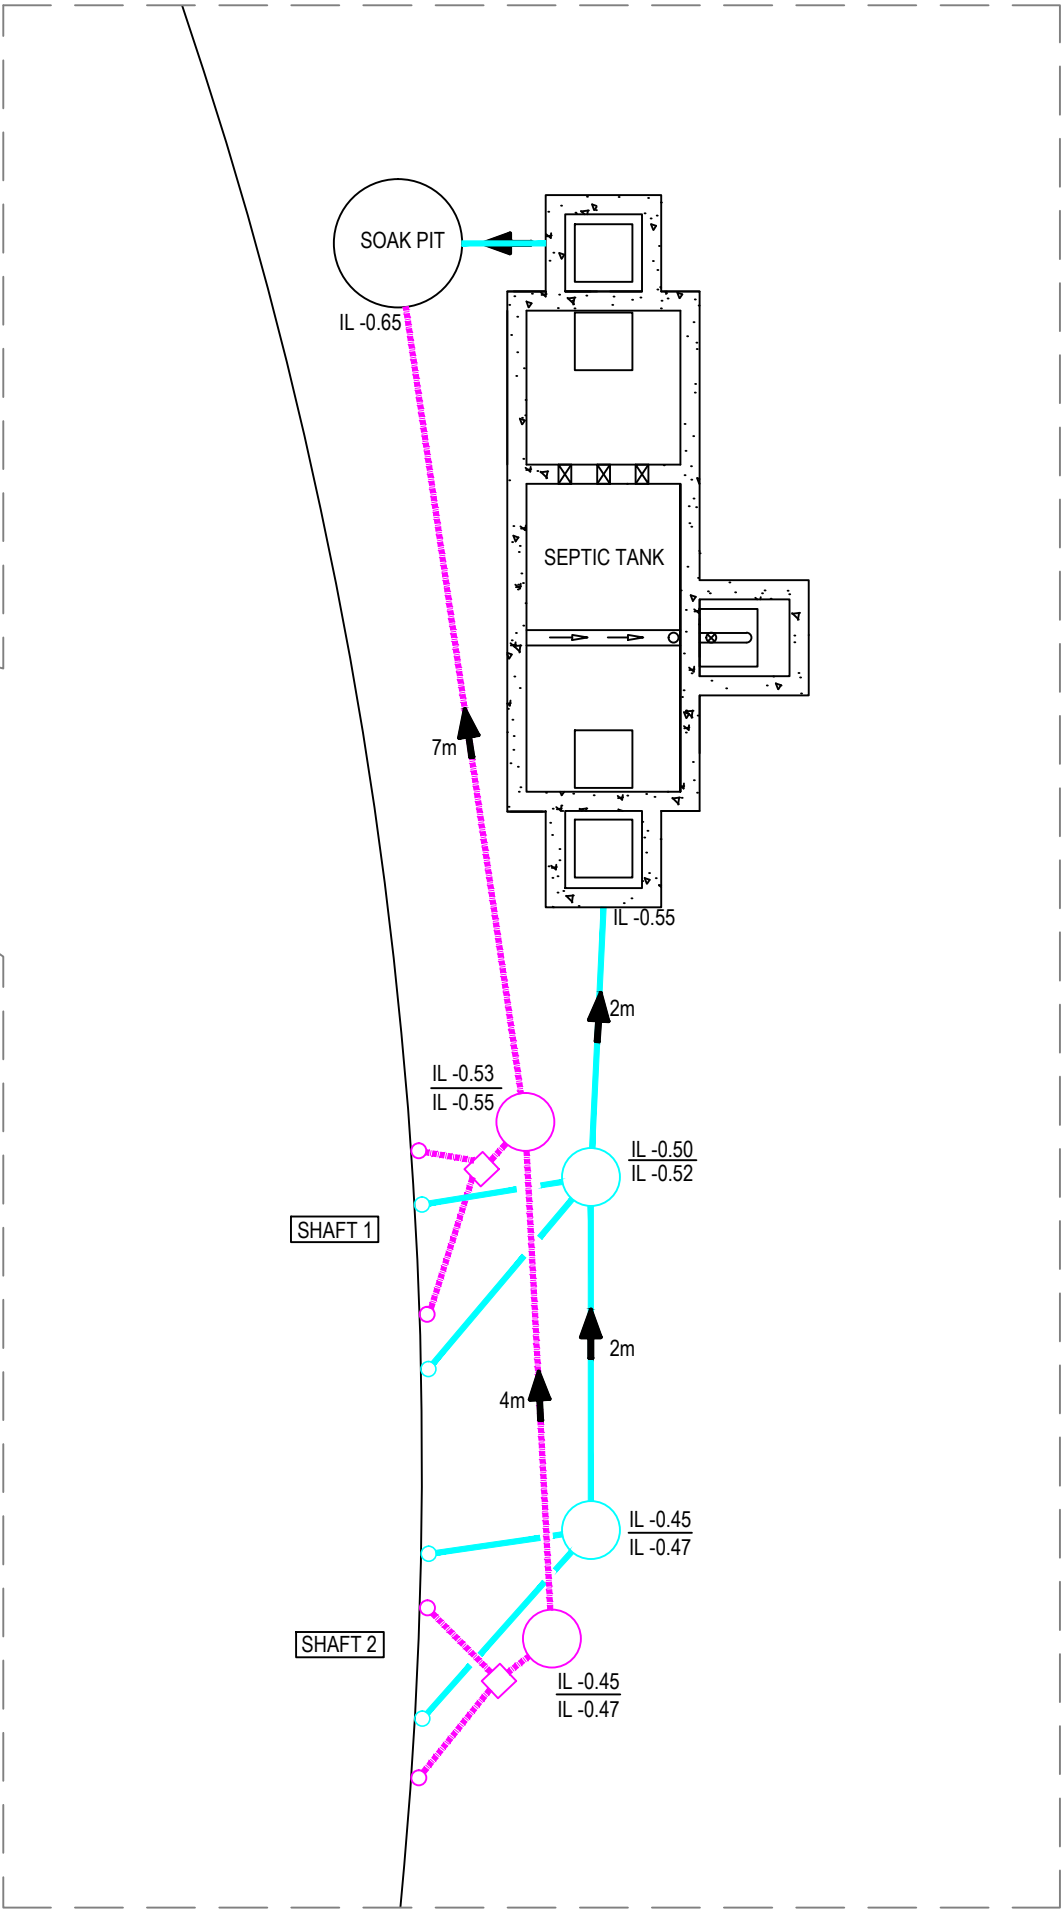

SITE PLAN SHOWING SEWER LINES  
SCALE 1:30



RAMJI

RAMJI AND ASSOCIATES

CIVIL ♦ MECHANICAL ♦ ELECTRICAL ♦ PLUMBING

TC 38/2526, Chalai P.O  
Thiruvananthapuram, Kerala  
INDIA, 695036  
Phone - 94470 79889  
email - jramsr@gmail.com

client

GOVT. OF KERALA

architect

HABITAT TECHNOLOGY  
GROUP, POOJAPPURA,  
TRIVANDRUM

project

AMPHITHEATRE AND  
WATER FOUNTAIN AT  
SCIENCE CITY

title

DETAILS OF SEWER LINES

project number

■ RAMJI/HAB/SC/11/14

date

■ 01/12/2014

drawn by

■ SHUJU

checked by

■ JRAM

sheet size.

■ A1

scale

■ AS SHOWN

revisions

■

pr number

■

date

■

includes sheets

■

drawings shall not be scaled for dimensions.  
written dimensions need to be followed.  
this drawing is property of RAMJI and should  
not be used or altered without their  
permission.  
All dimensions are in mm.

sheet number

■ P.AMP.05