

SYMBOL	DETAILS	QTY	SYMBOL	DETAILS	QTY	SYMBOL	DETAILS	QTY
	WING-CDX QUADRA 2x2 FITTING TBS570 4*TL5-14W HFODF-WH(PHILIPS)	23		BUSH LIGHT-6W SMART LED SPOT	23		SWITCH BOARD	
	2x28W SURFACE/SUSPENDED T5 FITTING (PHILIPS-TCS150)	9		CHANDLIER	1		20A POWER POINT	4
	WALL BRACKET-8W PHILIPS LED WALL MOUNT(BWS150)	10		UP DOWNLIGHT/LED WALL BRACKET-23W PHILIPS MEGAPOLIS CRESSIDA EWP300	12		16A SOCKET WITH SWITCH	14
	UNDER WATER LIGHT- (PHILIPS-NHG010)	5		17W WIPRO PLAY LED WIPRO LD51-012-XXX-WH-XX	15		6A SOCKET WITH SWITCH	13
	SURFACE MOUNTED 13W LED DOWNLIGHT WIPRO HALO CRDL	8		PICTURE LIGHT-PHILIPS BN 550 6W LED	7		TELEPHONE OUTLET	5
	4WLED STEPLIGHT -PHILIPS BWG150	18		23W HALO CRDL11023H57 WIPRO	12		TV POINT	5
	SURFACEMOUNTED 8W WIPRO HALO CRDL	8		60W EXHAUST FAN(POINT WIRING ONLY)	8		DATA	8
	6W IFEET LED BATTEN -PHILIPS LINEA	2		60W CEILING FAN (HAVELLS MAKE XP-390)	12		DISTRIBUTION BOARD	
	8W LEDBOLLARD LIGHT(PHILIPS-BCP150)	12						

GENERAL NOTES

LEGEND

FOR CLIENT

ARCHITECT

Habitat TECHNOLOGY GROUP

POOJAPPURA,THIRUVANANTHAPURAM-12, KERALA, INDIA

habitat@asianetindia.com

PROJECT

SCIENCE CITY

PALA

TITLE

ELECTRICAL

ENTRANCE PLAZA - PHYSICAL LAYOUT

DRAWING STATUS:FOR TENDOR PURPOSE


R3	09-03-15	CHANGES INCORPORATED
R2	26-02-15	LUMINAIRE DETAIL INCORPORATED
R1	03-02-15	CHANGES INCORPORATED

REV.	DATE	REMARKS

DRAWN:	ANSY	CHECKED:	RN	APPROVED:	NKS
PROJECT NO.	111	DWG NO.	EP-E-01	DATE:	29-11-14

ATS CONSULTANTS

Email: atsconsultants@hotmail.com Phone: 0471-4016170/ +91-8714 33 8631

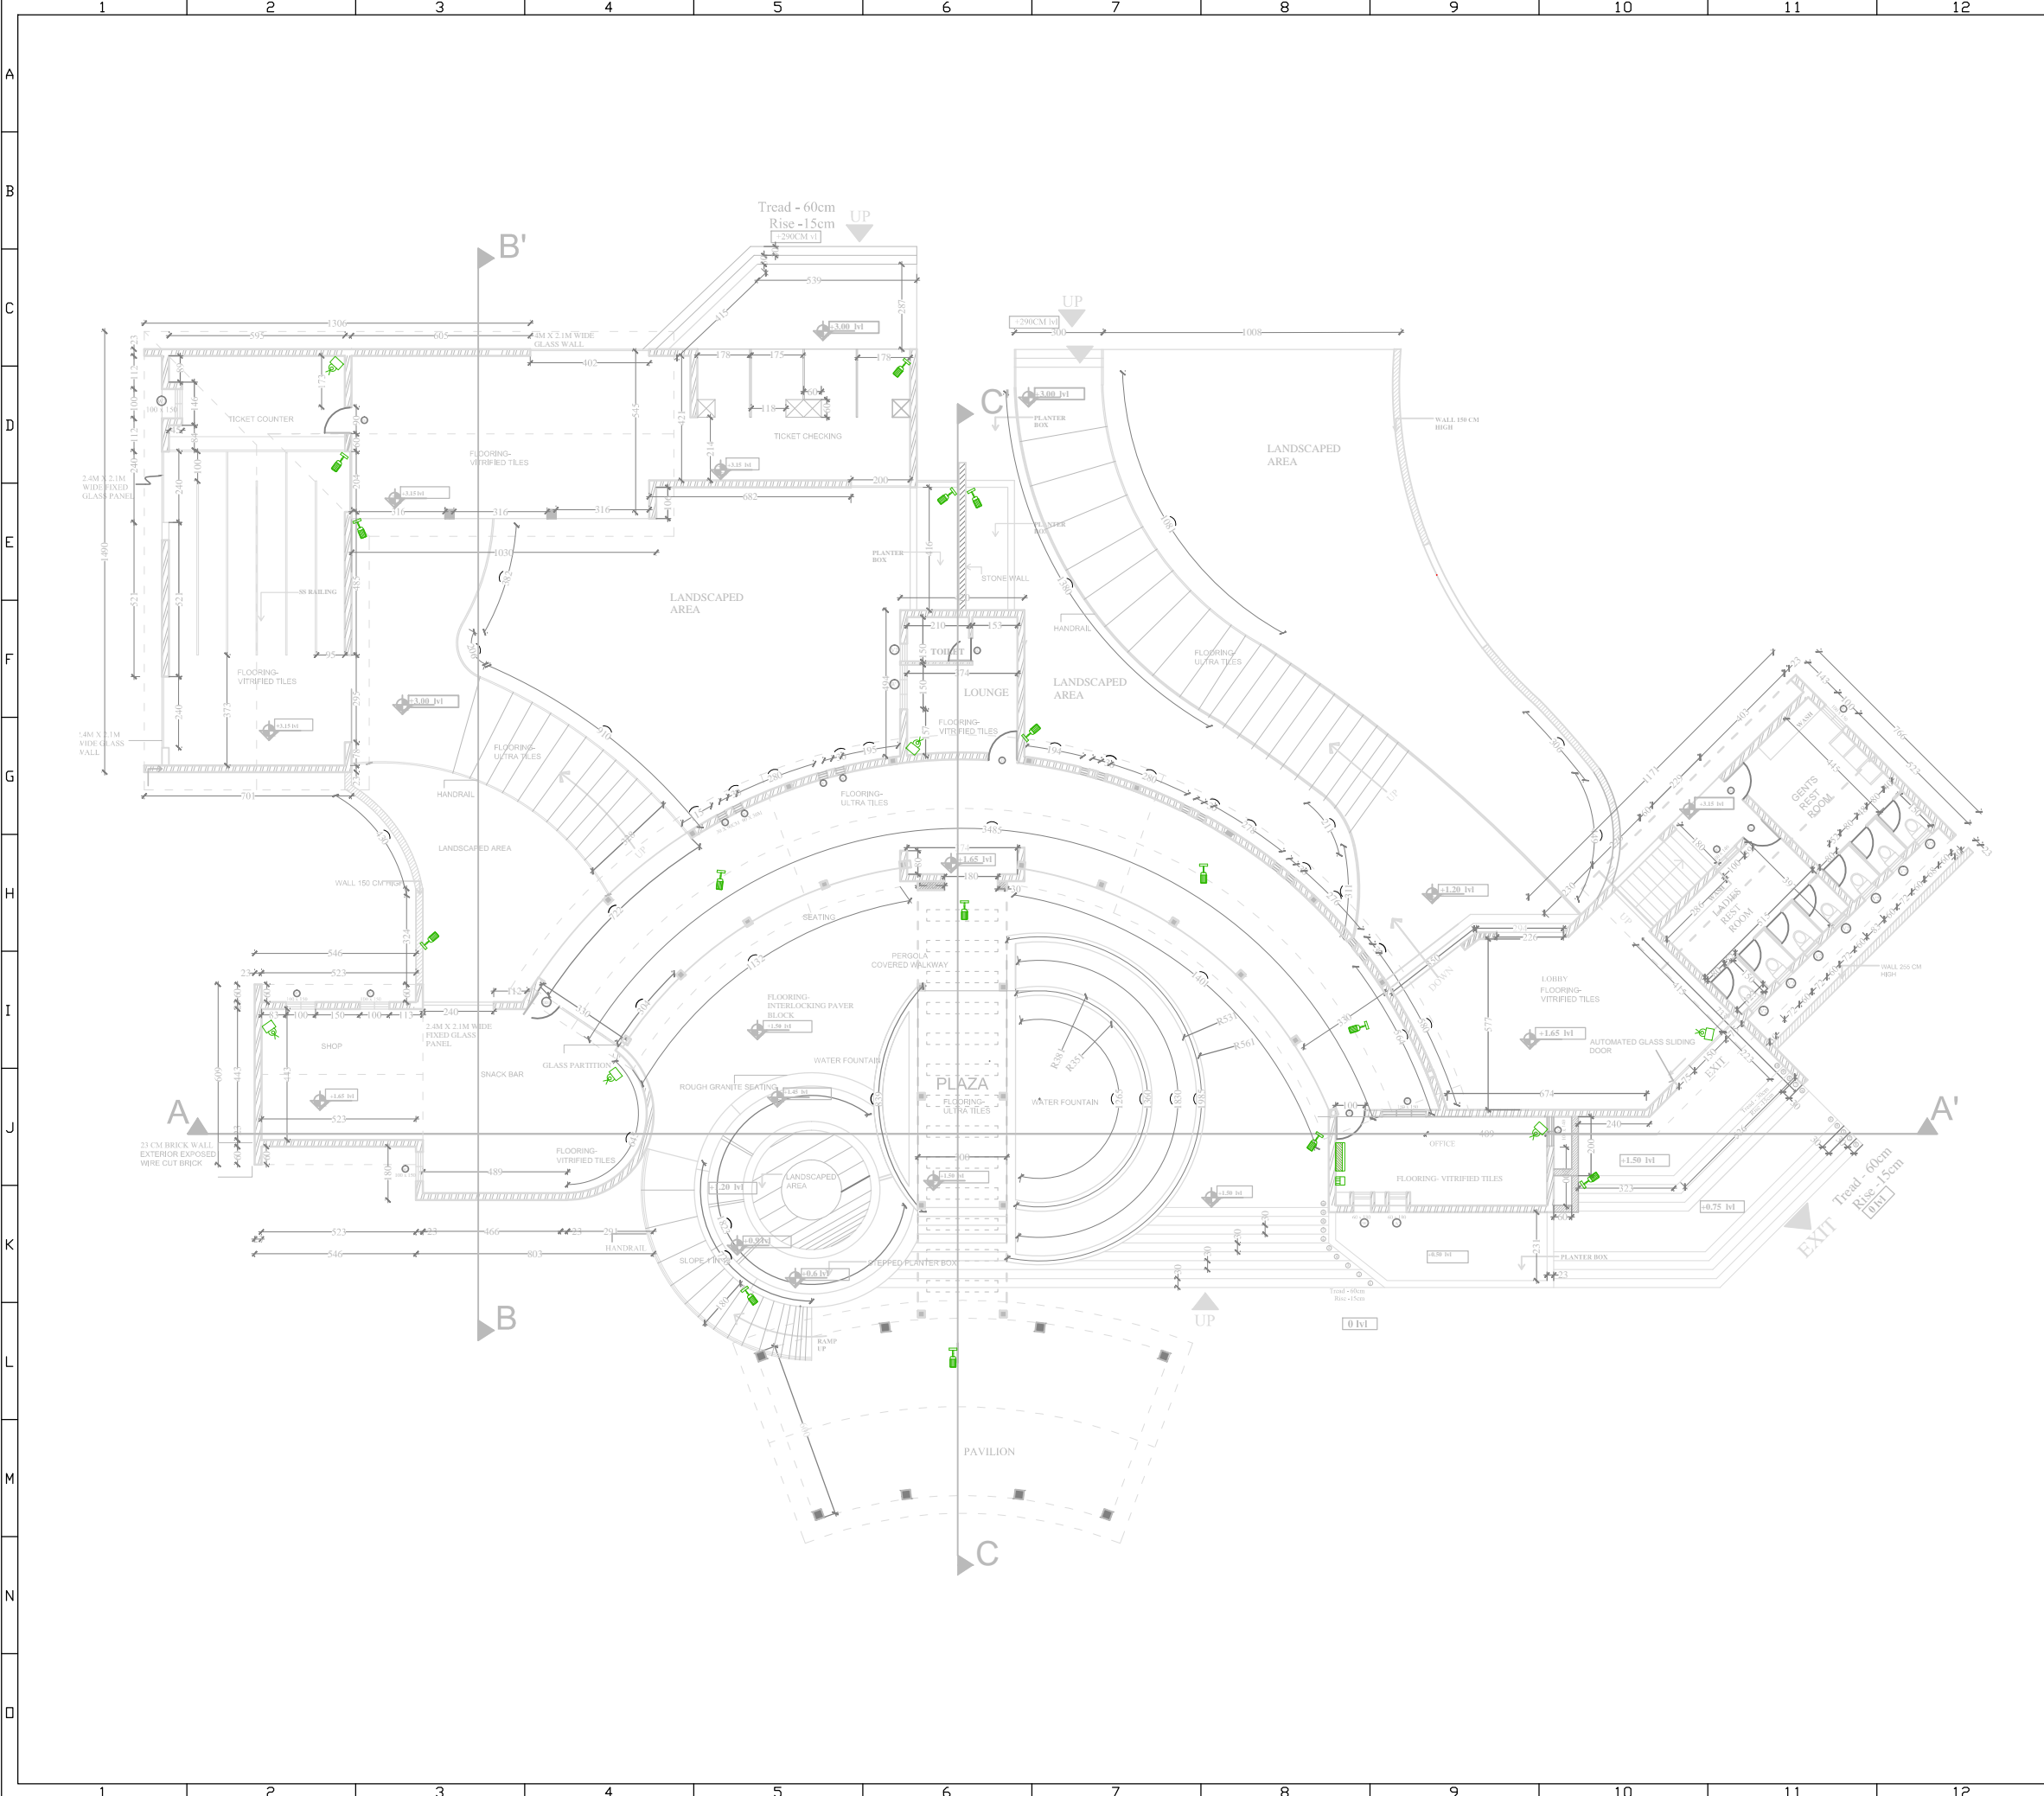

GENERAL NOTES

SYMBOL	DETAILS	QTY
	DOME CAMERA	06
	BULLET CAMERA	15
	WALL MOUNTED 9U RACK & 20PAIR KRONE BOX	01

FOR CLIENT

ARCHITECT

Habitat
TECHNOLOGY GROUP
POOJAPPURA, THIRUVANANTHAPURAM-12, KERALA, INDIA
habitat@asianetindia.com

PROJECT SCIENCE CITY
PALA

TITLE ELECTRICAL
ENTRANCE PLAZA - CCTV LAYOUT

DRAWING STATUS: FOR TENDOR PURPOSE

REV.	DATE	REMARKS
DRAWN:	ANSY	CHECKED: RN APPROVED: NKS
PROJECT NO.	111	DWG NO. EP-E-02 DATE: 09-03-15

ATS
CONSULTANTS
Email: atsconsultants@hotmail.com Phone: 0471-4016170/ +91-8714 33 8631